








**Figure ST26
Site Map with
Site Level Features
Sea Girt Armory
Bldg 8
Floor 2**

Legend


Sea Girt Building 8 2nd Floor

-  Refrigeration Unit
-  Drinking Water Fountain
-  Hot Water Heater
-  Light Ballast
-  No Access
-  Water Cooler

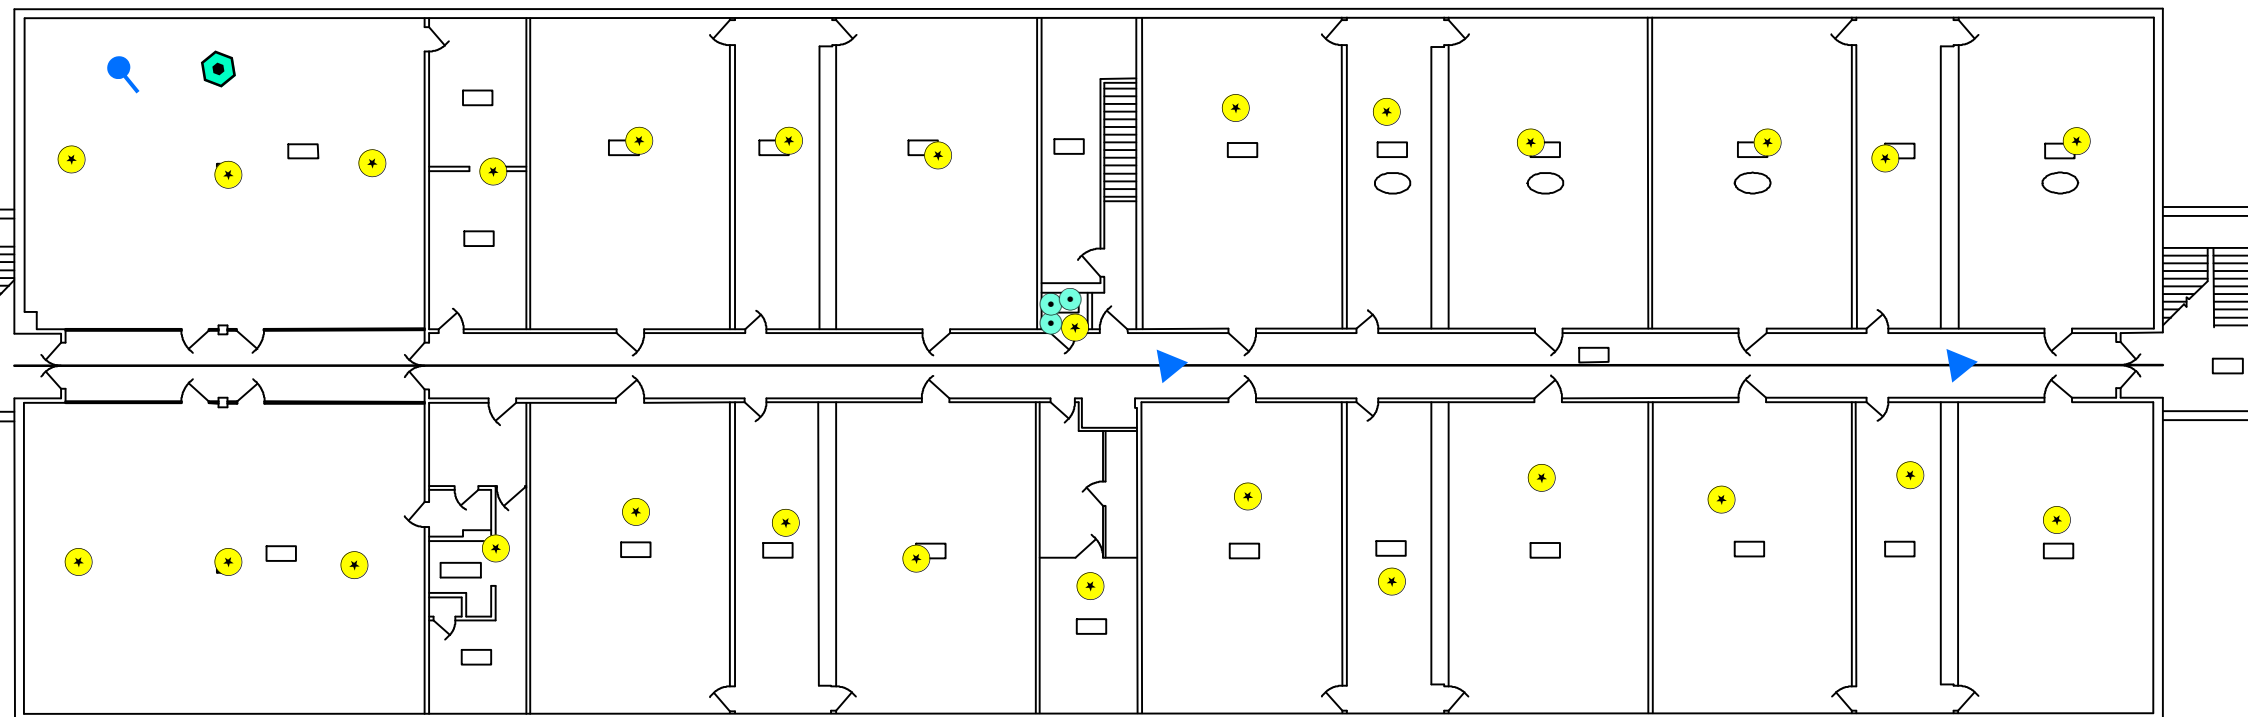

0 10 20 40 Feet

1 inch = 20 feet

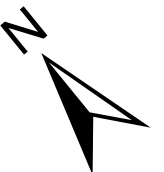

Notes:

Floor plans georeferenced via headsup digitizing over 2015 aerial photography
Locations of air emissions, ODS, and FLBs georeferenced via floor plans



Scale: 1 inch = 20 feet


File: ST26

Date: 5/21/2019

Created By: Rosalie Hood,
Anne Timmreck,
Raina Ryan,
Alexandria Petrosch





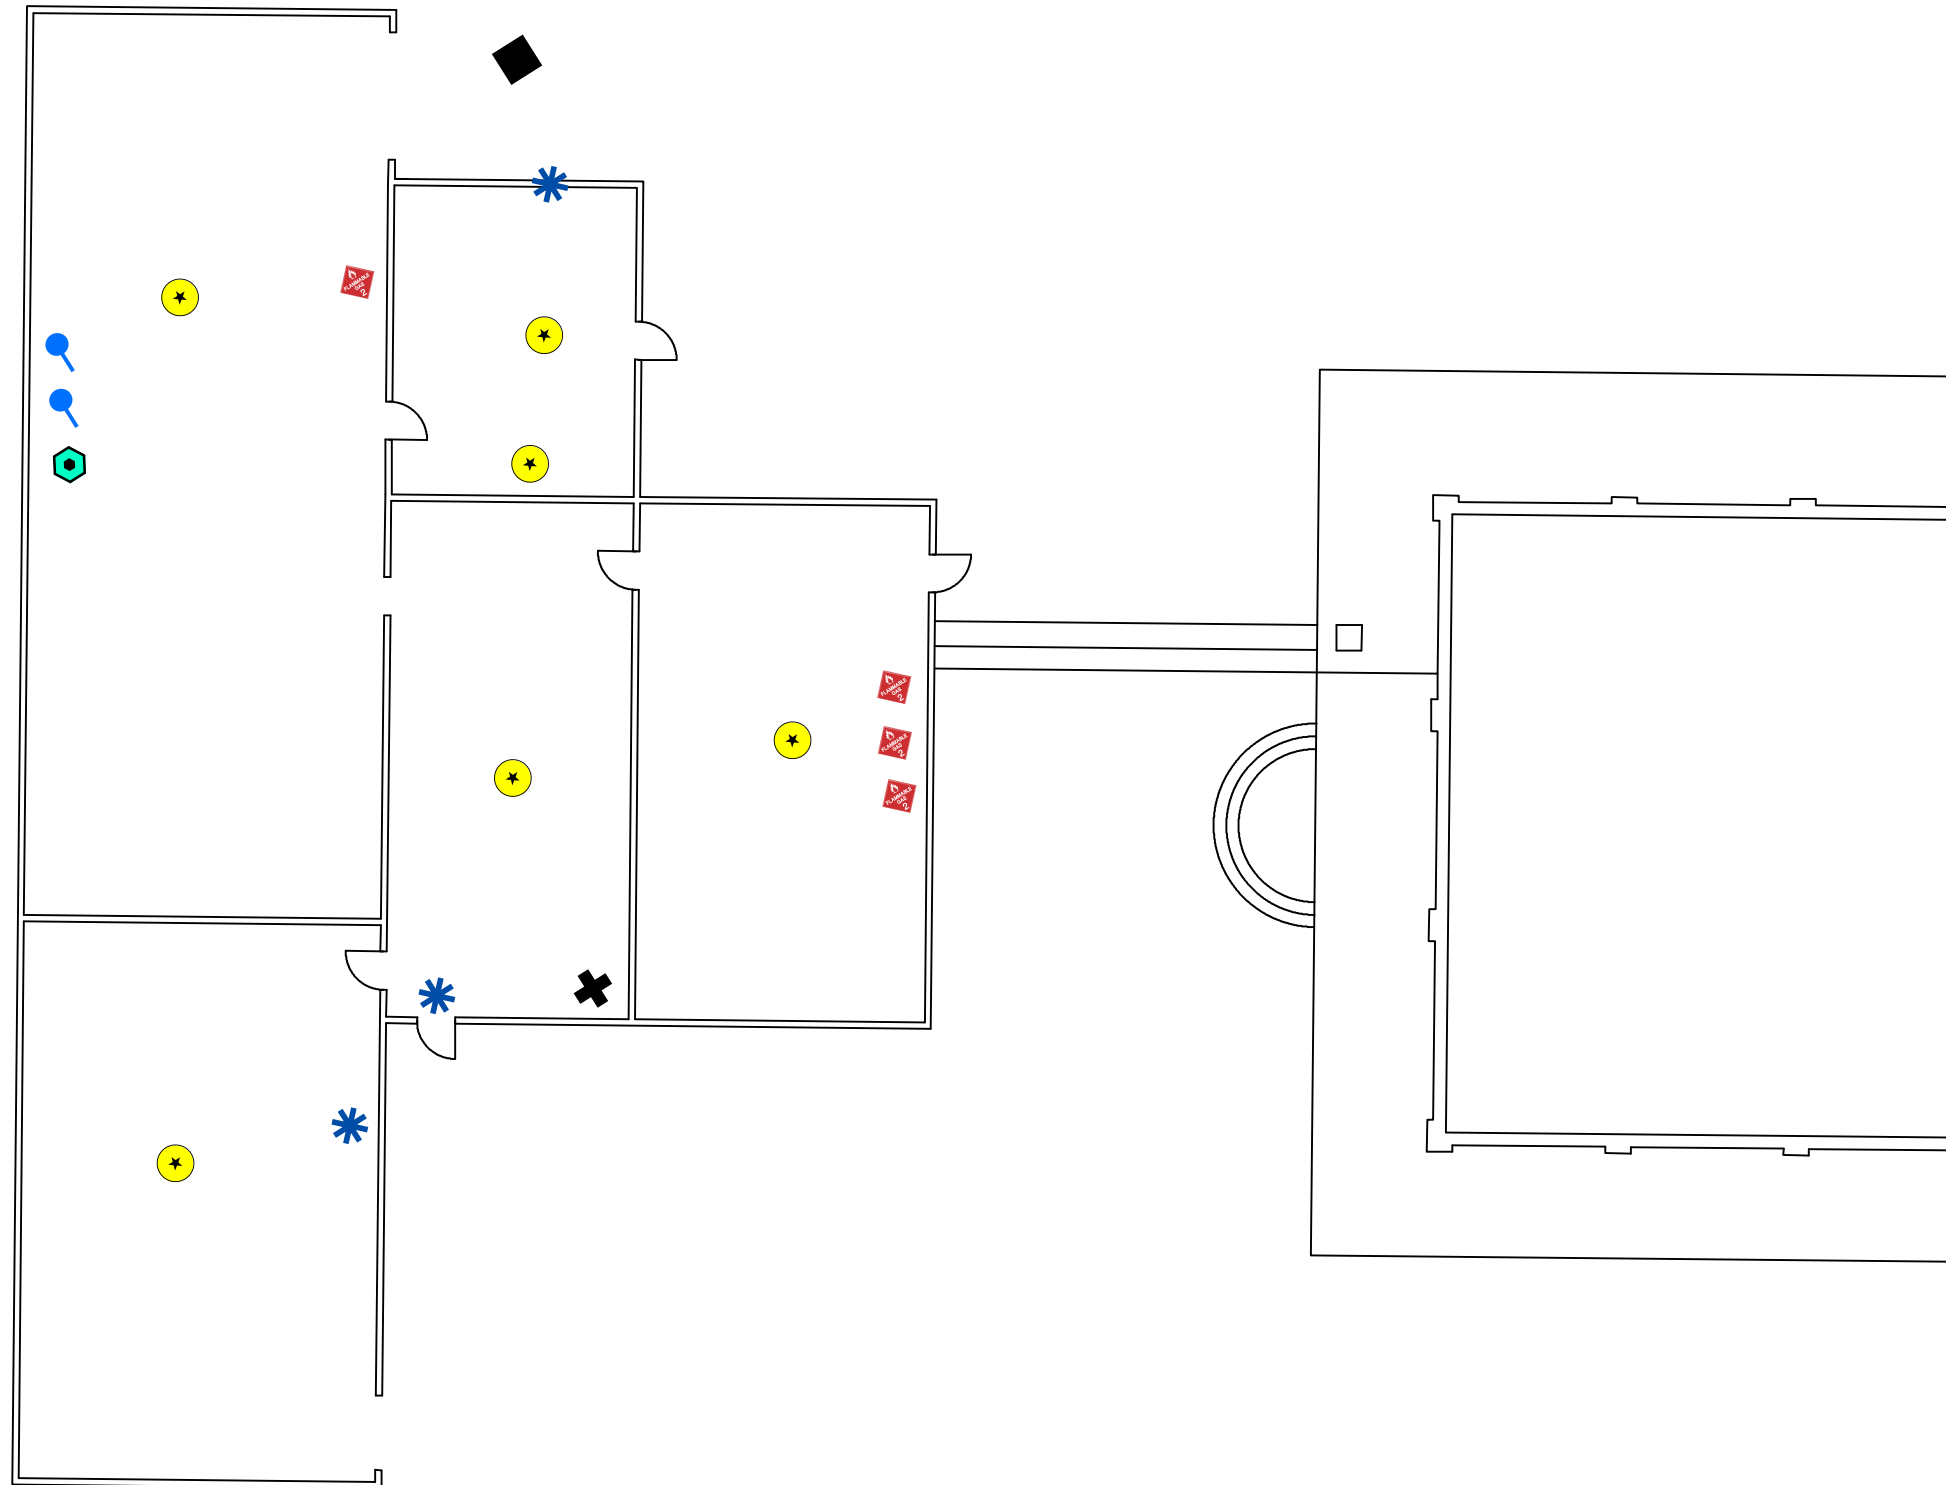


**Rowan
University
&
Stockton
University**

**Figure ST27
Site Map with
Site Level Features
Sea Girt Warehouse & Off
Bldg 59**



Legend

Sea Girt Building 59 1st Floor

-  Air Conditioning Unit
-  Boiler
-  Flammable Cabinet
-  Light Ballast
-  Storage Tank
-  Water Cooler
-  Refrigeration Unit

0 7.5 15 30 Feet
1 inch = 15 feet



Notes:


Floor plans georeferenced via headsup digitizing over 2015 aerial photography
Locations of air emissions, ODS, and FLBs georeferenced via floor plans



Scale: 1 inch = 15 feet
File: ST27
Date: 5/21/2019
Created By: Rosalie Hood,
Anne Timmreck,
Raina Ryan,
Alexandria Petrosch



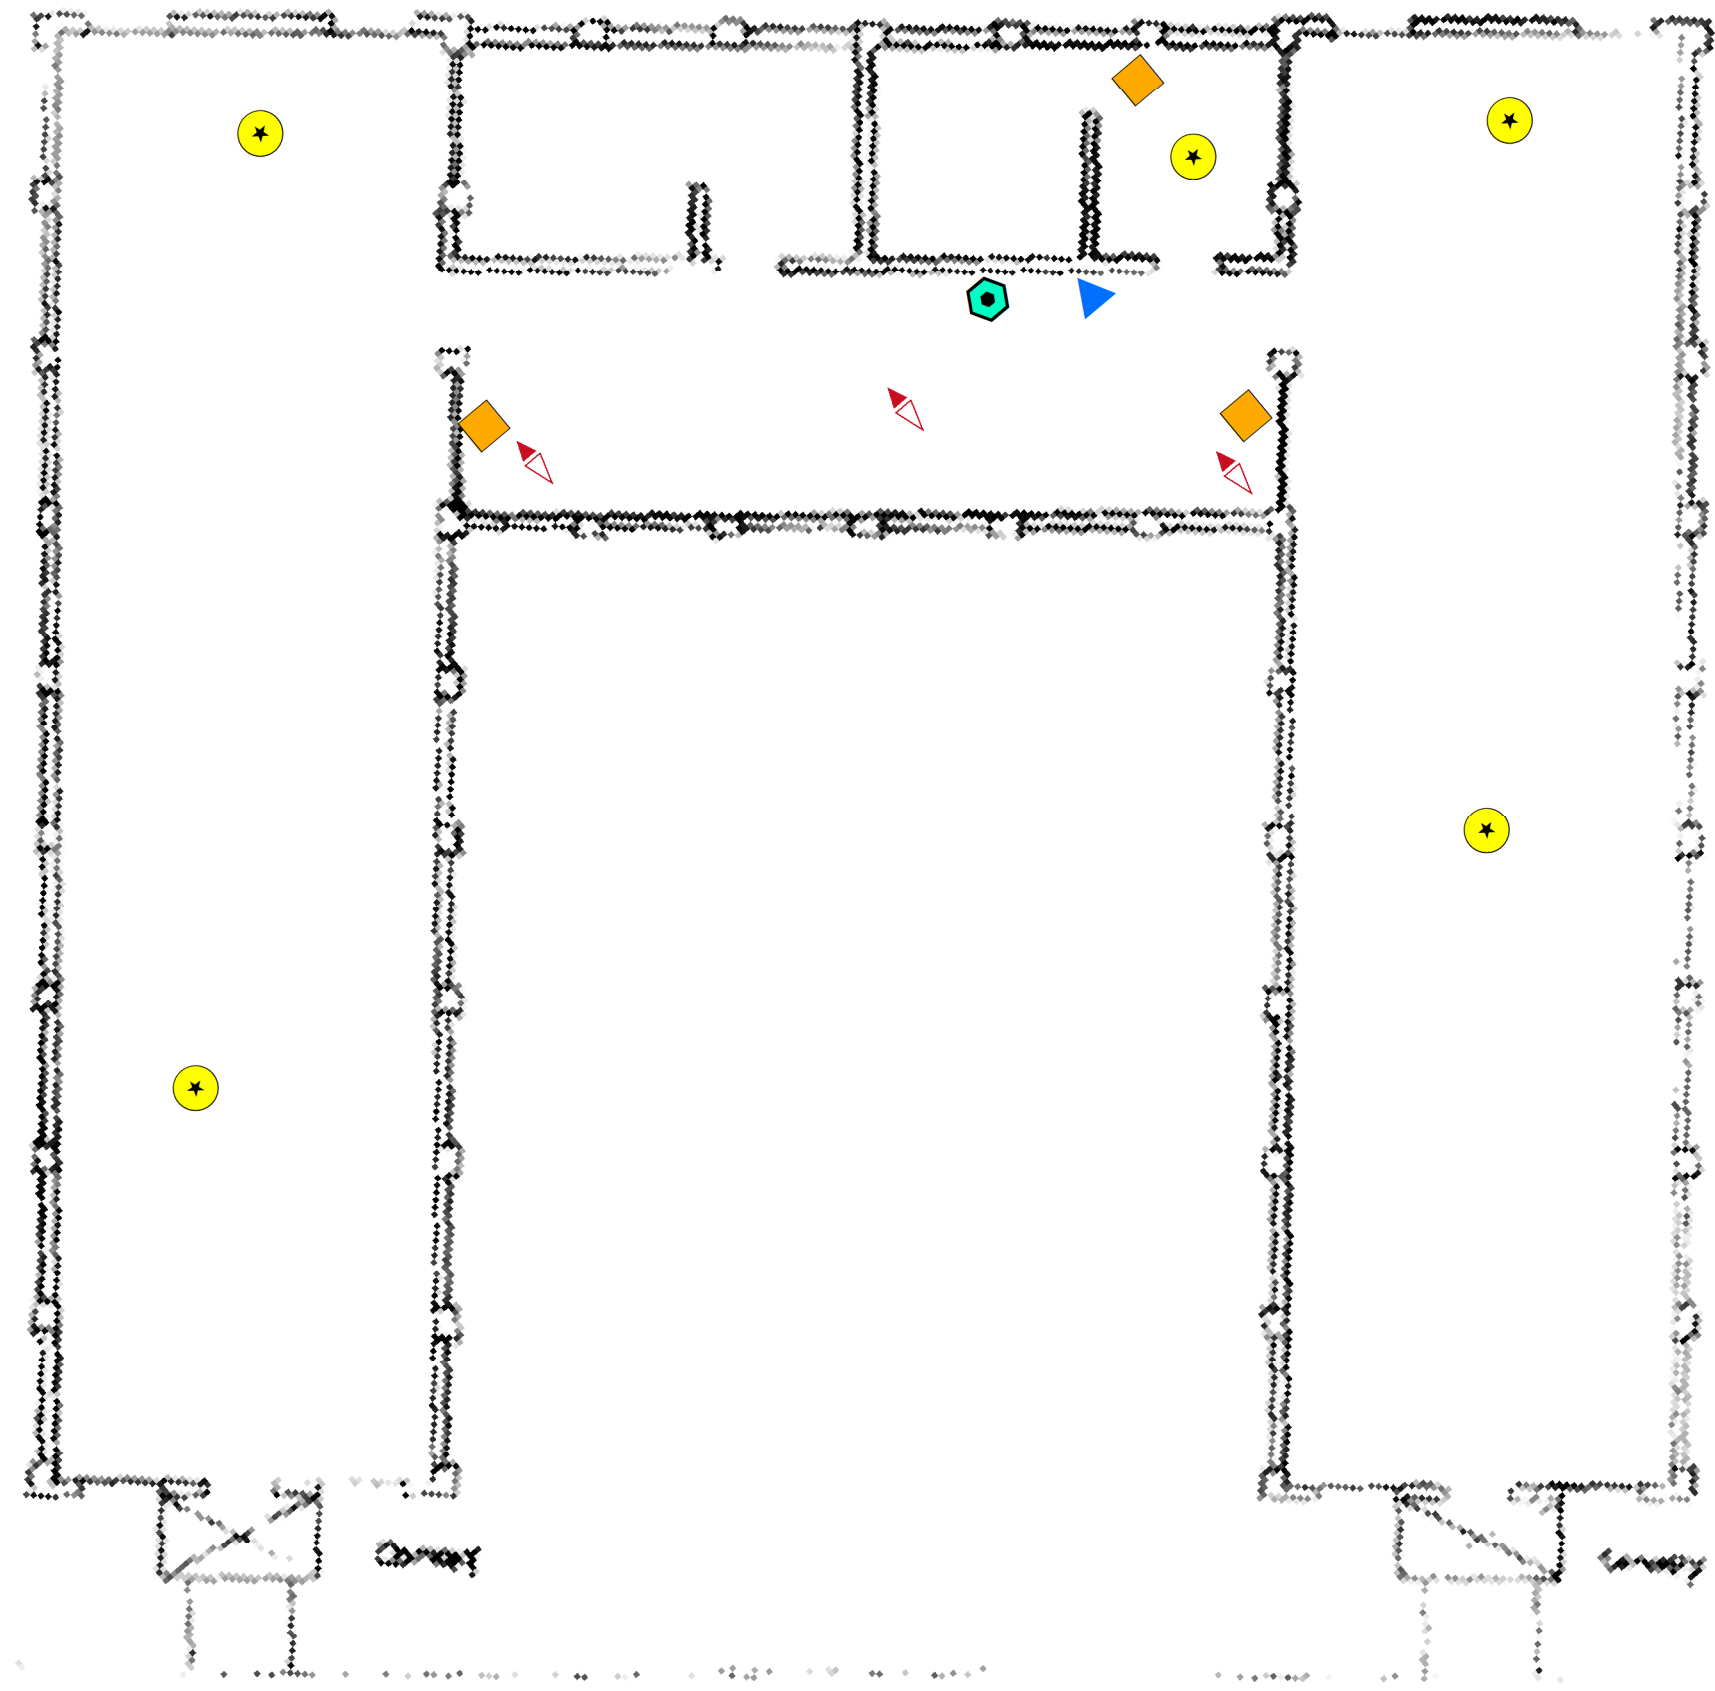


**Rowan
University
&
Stockton
University**


**Figure ST45
Site Map with
Site Level Features
Sea Girt Armory
Bldg 15**




Legend

Sea Girt Building 15 1st Floor

 -  Drinking Water Fountain
-  Forced Air Heater
-  Light Ballast
-  No FLBs
-  Refrigeration Unit



1 inch = 10 feet

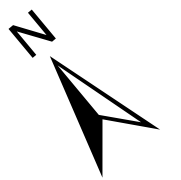

Notes:


Floor plans georeferenced via headsup digitizing over 2015 aerial photography
Locations of air emissions, ODS, and FLBs georeferenced via floor plans



Scale: 1 inch = 10 feet
File: ST45
Date: 5/21/2019
Created By: Rosalie Hood
Anne Timmreck,
Raina Ryan,
Alexandria Petrosch





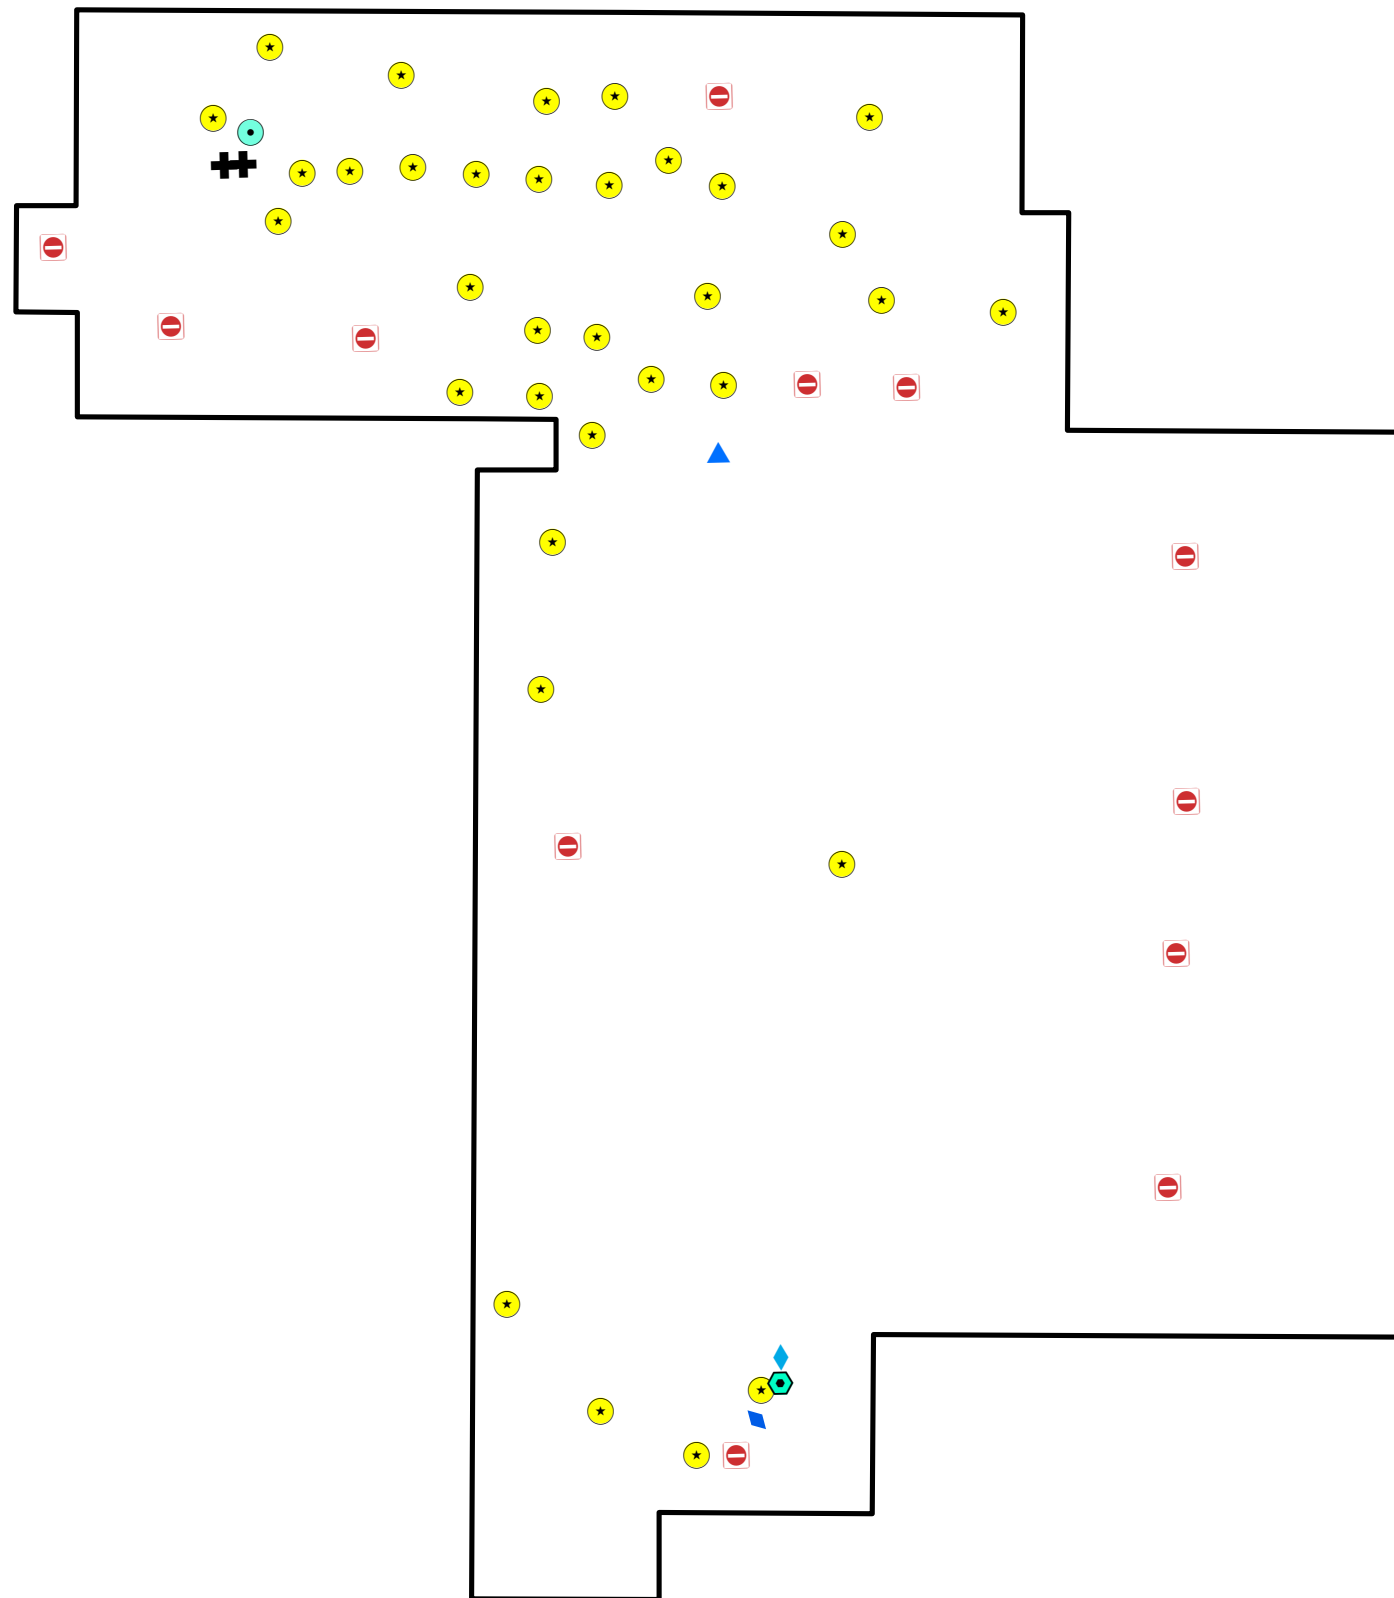




**Rowan
University
&
Stockton
University**


**Figure SS1
Site Map with
Site Level Features
Somerset Armory
Floor 1**



Legend

Somerset Armory Floor 1

-  Boiler
-  Drinking Water Fountain
-  Freezer Unit
-  Hot Water Heater
-  Ice Machine
-  Light Ballast
-  No Access
-  Refrigeration Unit
-  Somerset Armory Building Outline

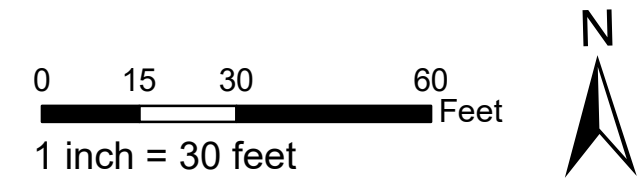

Notes:

Floor plans georeferenced via headsup digitizing over 2015 aerial photography
Locations of air emissions, ODS, and FLBs georeferenced via floor plans



Scale: 1 inch = 30 feet


File: SS1

Date: 5/29/2019

Created By: Rosalie Hood,
Alexandria Petrosch





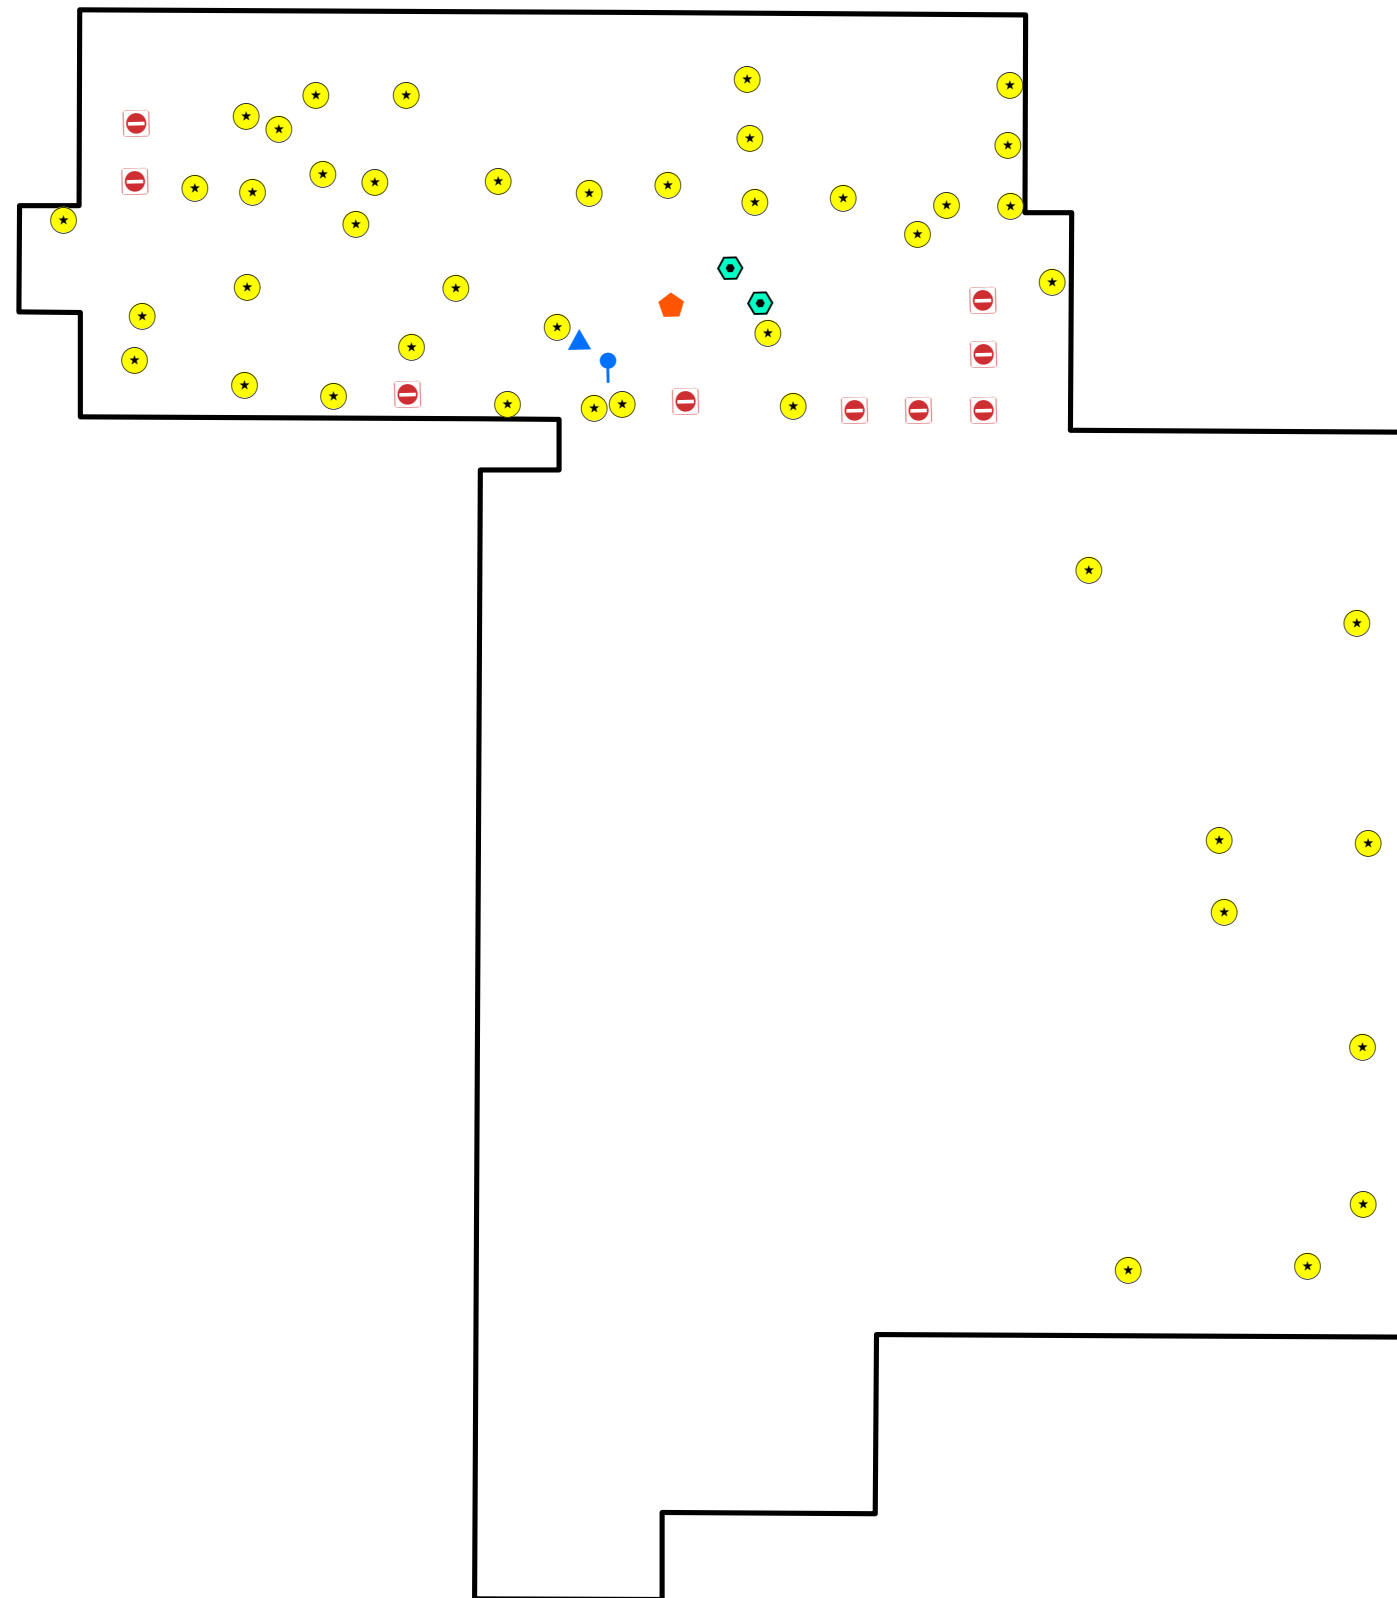


Rowan
University
&
Stockton
University


**Figure SS2
Site Map with
Site Level Features
Somerset Armory
Floor 2**



Legend

Somerset Armory Floor 2

-  Dehumidifying Unit
-  Drinking Water Fountain
-  Light Ballast
-  No Access
-  Refrigeration Unit
-  Water Cooler
-  Somerset Armory Building Outline

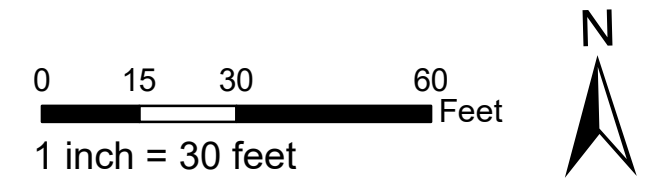

Notes:

Floor plans georeferenced via headsup digitizing over 2015 aerial photography
Locations of air emissions, ODS, and FLBs georeferenced via floor plans



Scale: 1 inch = 30 feet


File: SS2

Date: 5/29/2019

Created By: Rosalie Hood,
Alexandria Petrosch

**Rowan
University
&
Stockton
University**



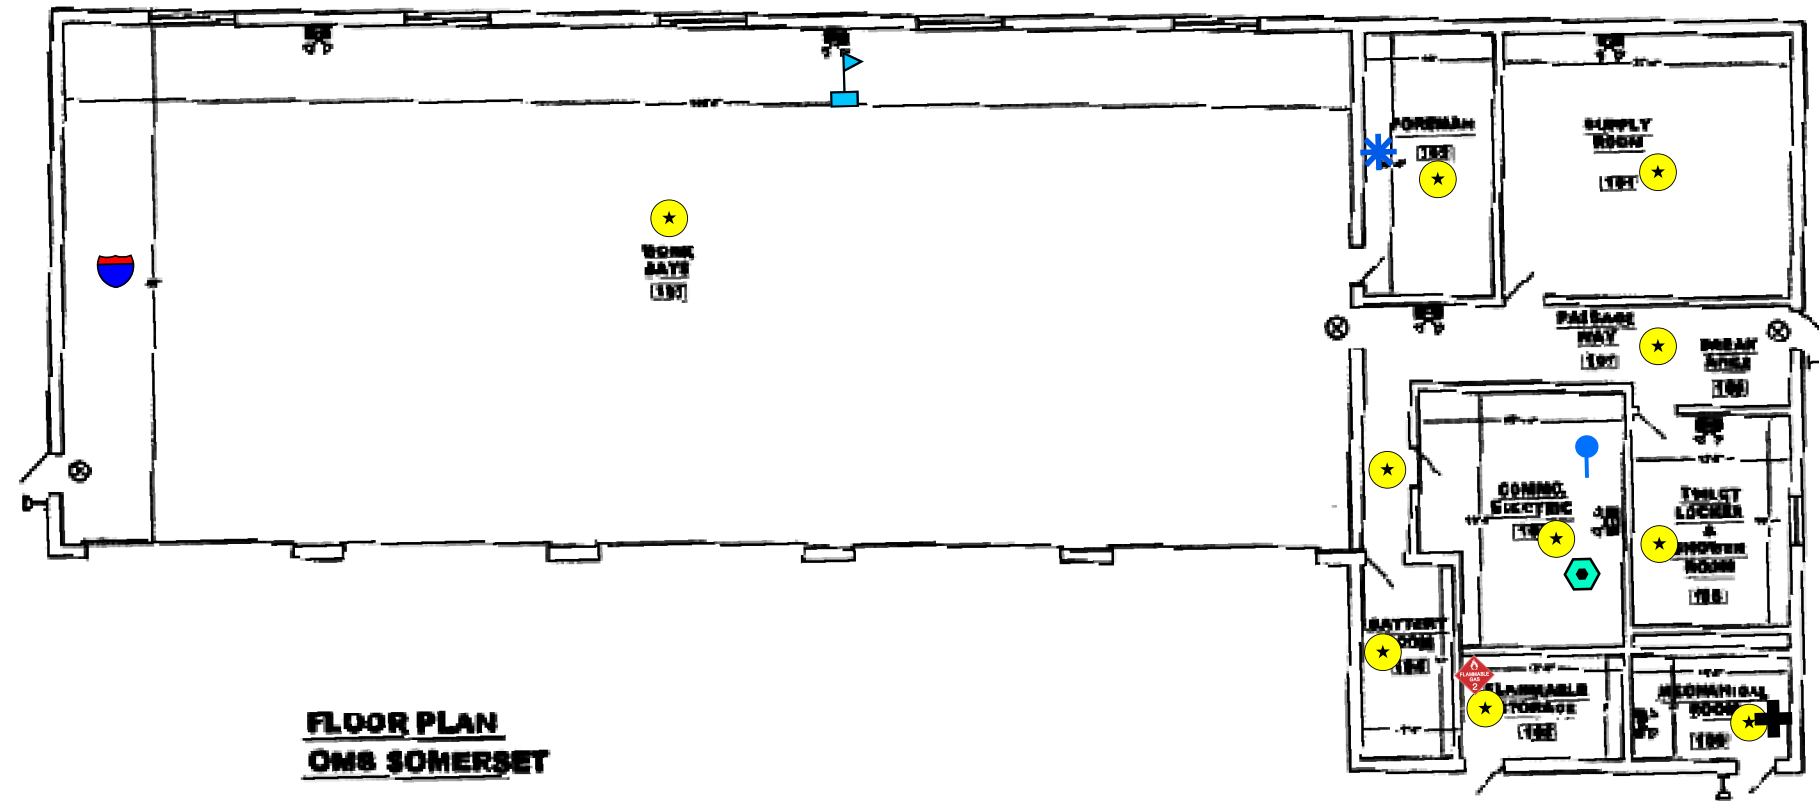





**Figure SS3
Site Map with
Site Level Features
Somerset FMS
Floor 1**



**FLOOR PLAN
OMS SOMERSET**

Legend

Somerset FMS Floor 1

-  Air Conditioning Unit
-  Boiler
-  Flammable Cabinet
-  Light Ballast
-  Parts Washer
-  Refrigeration Unit
-  Vehicle Recovery Air Conditioning Unit
-  Water Cooler

0 7.5 15 30 Feet

1 inch = 15 feet



Notes:

Floor plans georeferenced via headsup digitizing over 2015 aerial photography
Locations of air emissions, ODS, and FLBs georeferenced via floor plans



Scale: 1 inch = 15 feet

File: SS3

Date: 5/29/2019

Created By: Rosalie Hood,
Alexandria Petrosch

**Rowan
University
&
Stockton
University**

**Figure SS4
Site Map with
Site Level Features
Somerset DTMB
Floor 1**


Legend

Somerset DTMB Floor 1

- ▼ Infrared Heater
- ★ Light Ballast

0 7.5 15 30 Feet

1 inch = 15 feet

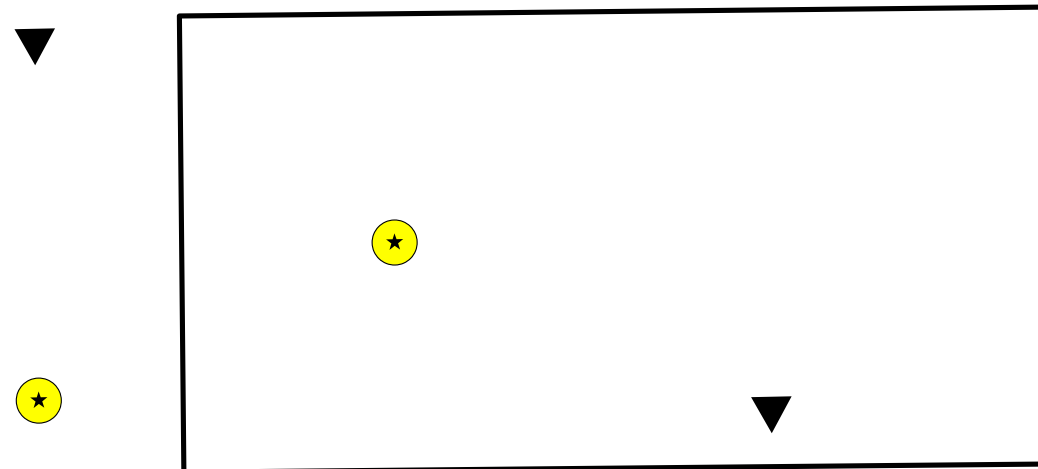

Notes:


Floor plans georeferenced via headsup digitizing over 2015 aerial photography
Locations of air emissions, ODS, and FLBs georeferenced via floor plans



Scale: 1 inch = 15 feet
File: SS4
Date: 5/29/2019
Created By: Rosalie Hood,
Michael Hoffman,
Alexandria Petrosch





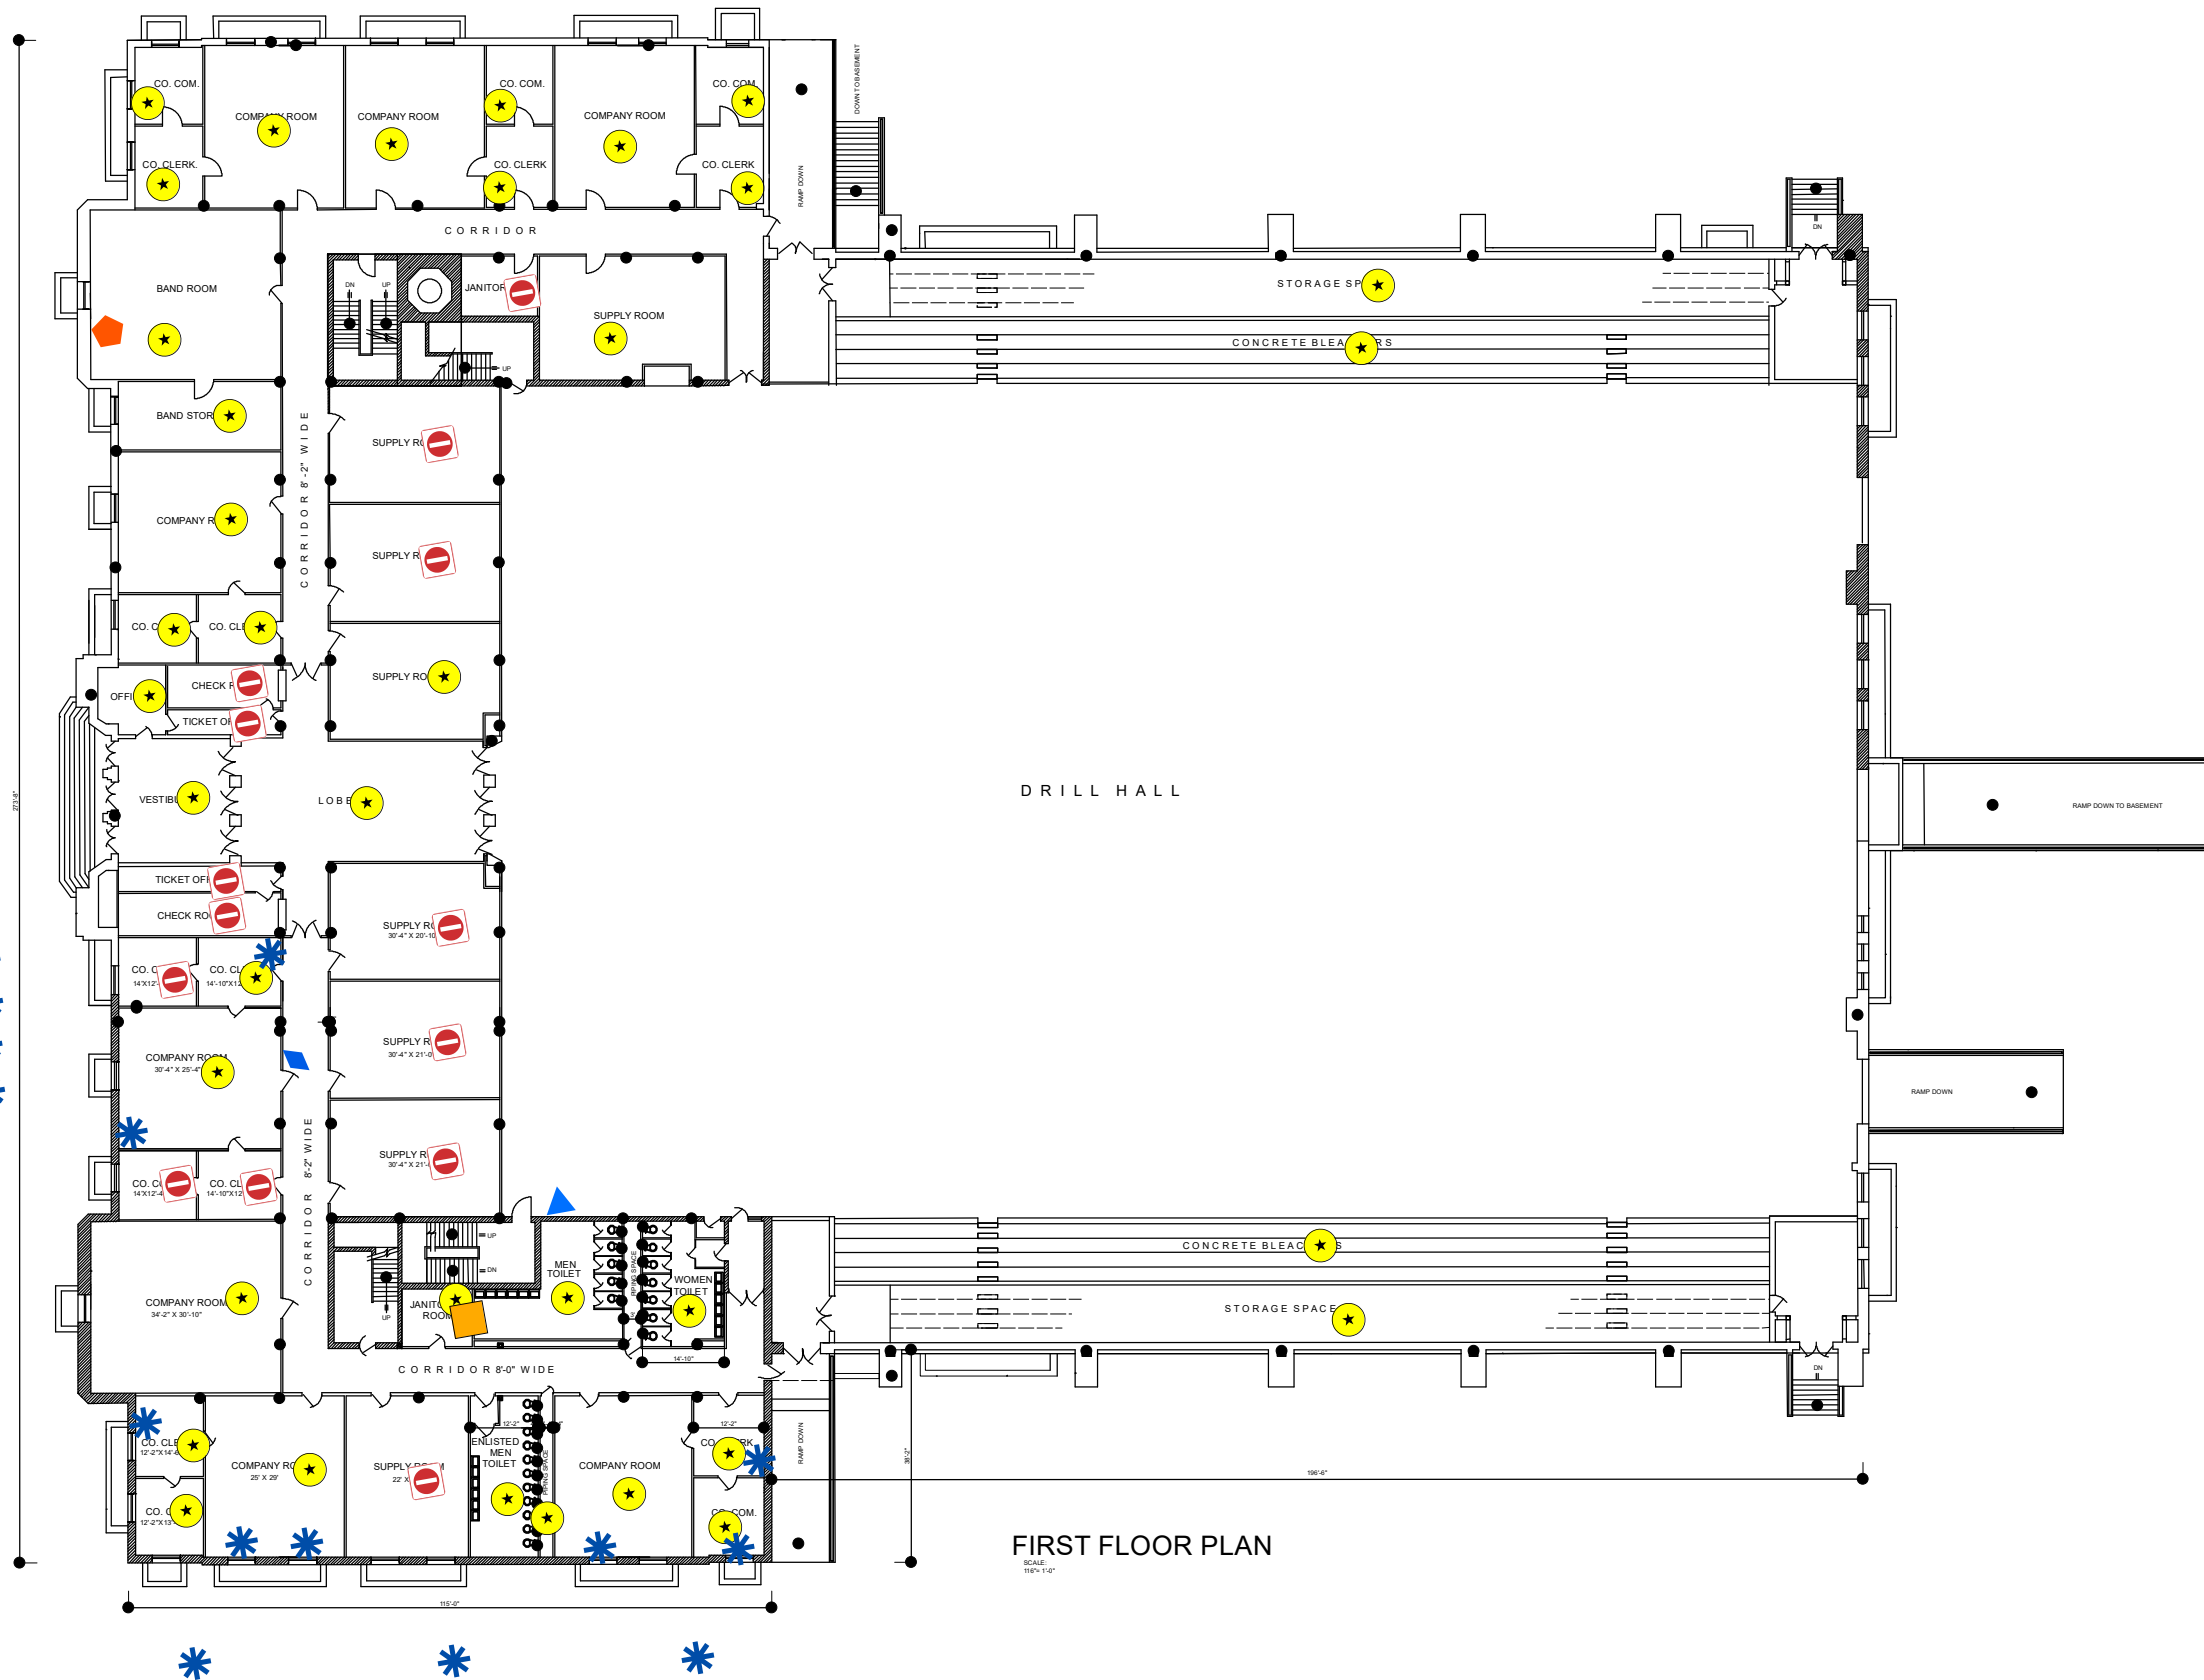



**Rowan
University
&
Stockton
University**

**Figure TK 1
Site Map with
Site Level Features
Teaneck Armory
Floor 1**



Legend

Teaneck Armory 1st Floor

-  Air Conditioning Unit
-  Dehumidifying Unit
-  Drinking Water Fountain
-  Forced Air Heater
-  Ice Machine
-  Light Ballast
-  No Access
-  Split Unit (Air Conditioner/Heater)

0 17.5 35 70 Feet
1 inch = 35 feet



Notes:


Floor plans georeferenced via headsup digitizing over 2015 aerial photography
Locations of air emissions, ODS, and FLBs georeferenced via floor plans



Scale: 1 inch = 35 feet
File: TK 1
Date: 5/21/2019
Created By: Rosalie Hood,
Tim Ivancich,
Alexandria Petrosch





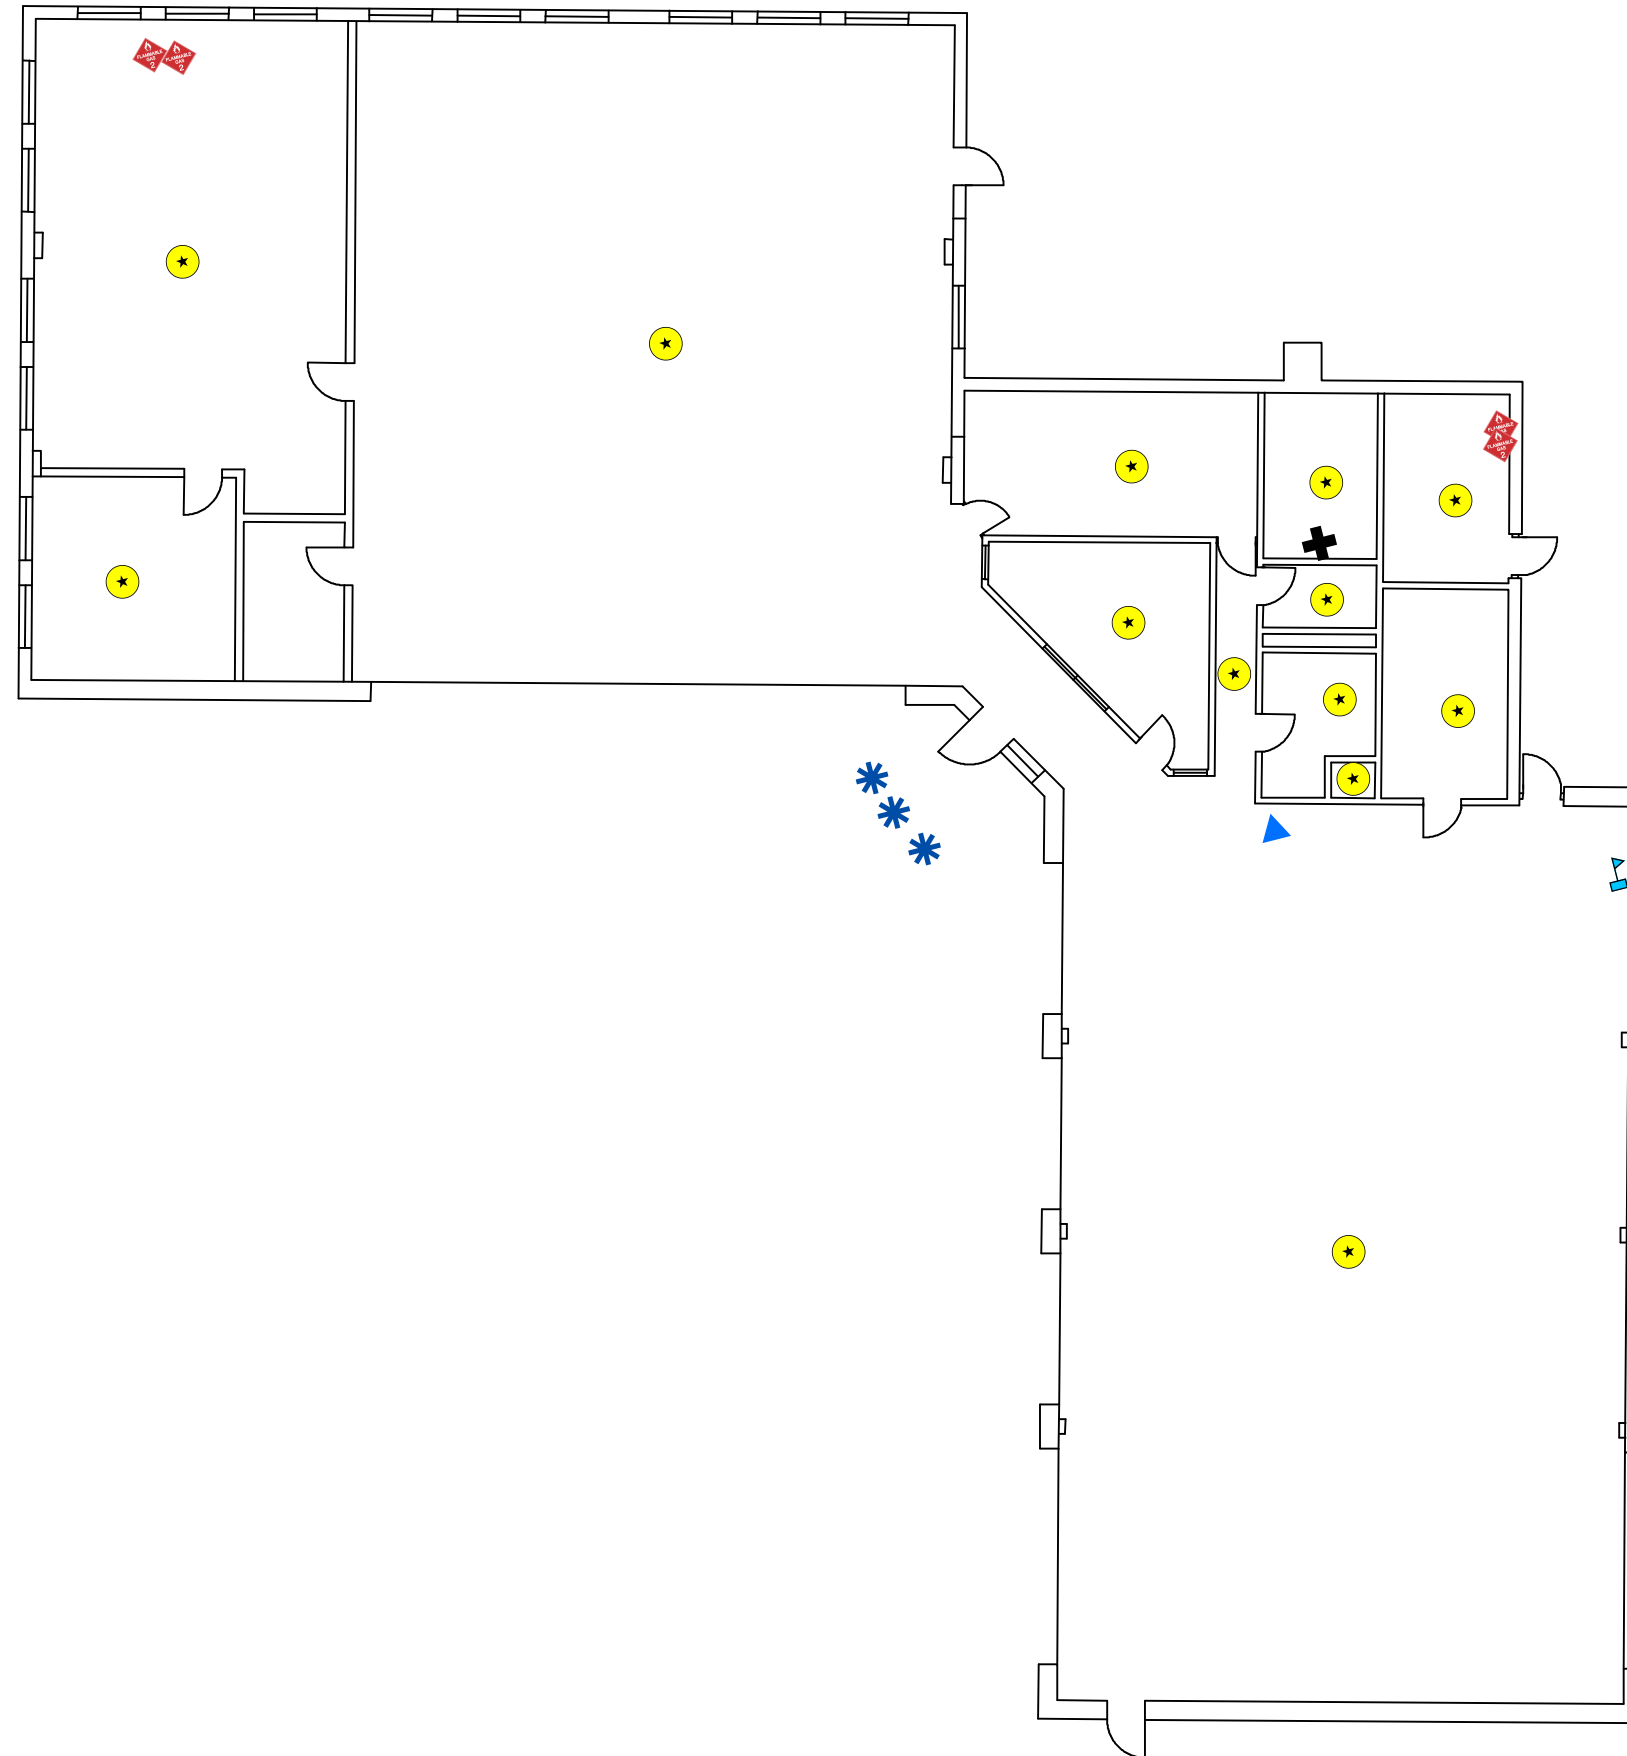

**Rowan
University
&
Stockton
University**

**Figure TK2
Site Map with
Site Level Features
Teaneck OMS
Floor**



Legend

Teaneck OMS 1st Floor

-  Air Conditioning Unit
-  Boiler
-  Drinking Water Fountain
-  Flammable Cabinet
-  Light Ballast
-  Parts Washer



1 inch = 15 feet



Notes:

Floor plans georeferenced via headsup digitizing over 2015 aerial photography
Locations of air emissions, ODS, and FLBs georeferenced via floor plans







Scale: 1 inch = 15 feet
File: TK2
Date: 5/21/2019
Created By: Rosalie Hood,
Tim Ivancich,
Alexandria Petrosch


**Rowan
University
&
Stockton
University**

**Figure TK3
Site Map with
Site Level Features
Teaneck DTMB
Floor 1**

Legend


Teaneck DTMB 1st Floor

-  Hot Water Heater
-  Infrared Heater
-  Light Ballast
-  Vehicle Recovery Air Conditioning Unit

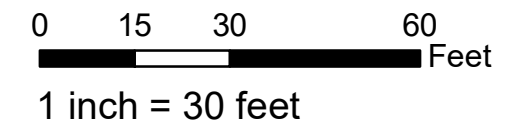

Notes:


Floor plans georeferenced via headsup digitizing over 2015 aerial photography
Locations of air emissions, ODS, and FLBs georeferenced via floor plans

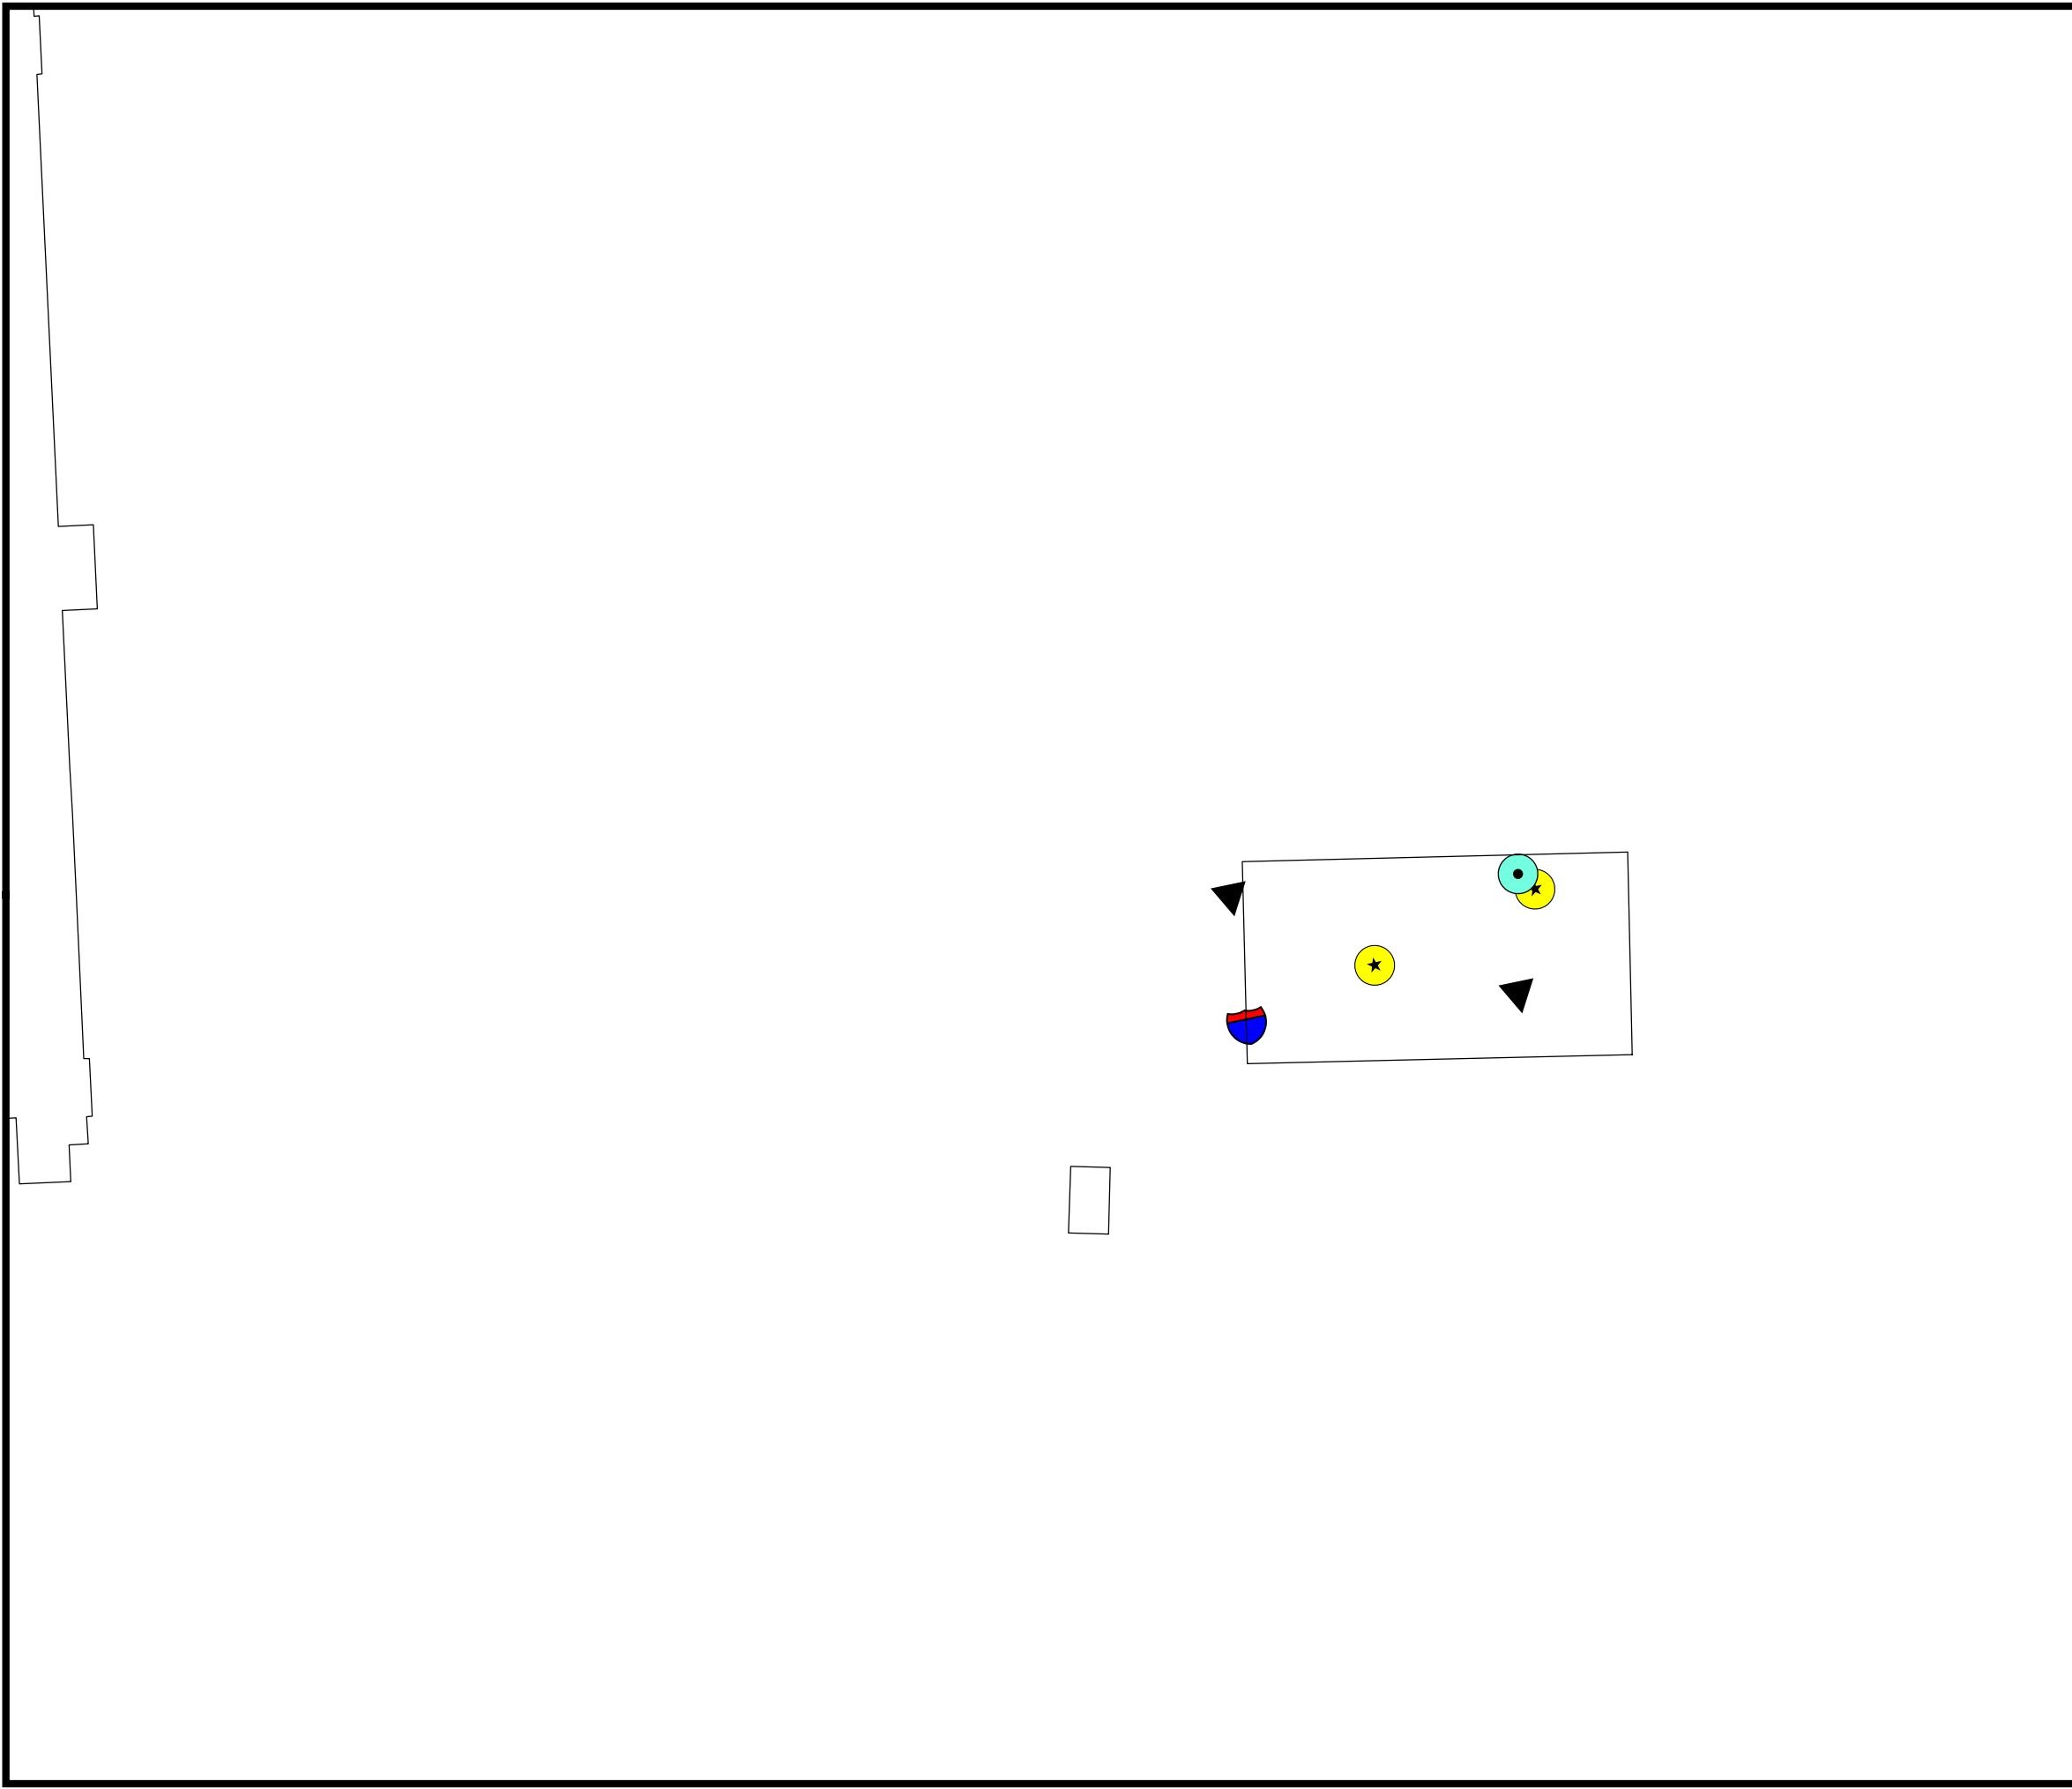

Scale: 1 inch = 30 feet
File: TK3
Date: 5/21/2019
Created By: Rosalie Hood,
Michael Hoffman,
Alexandria Petrosch





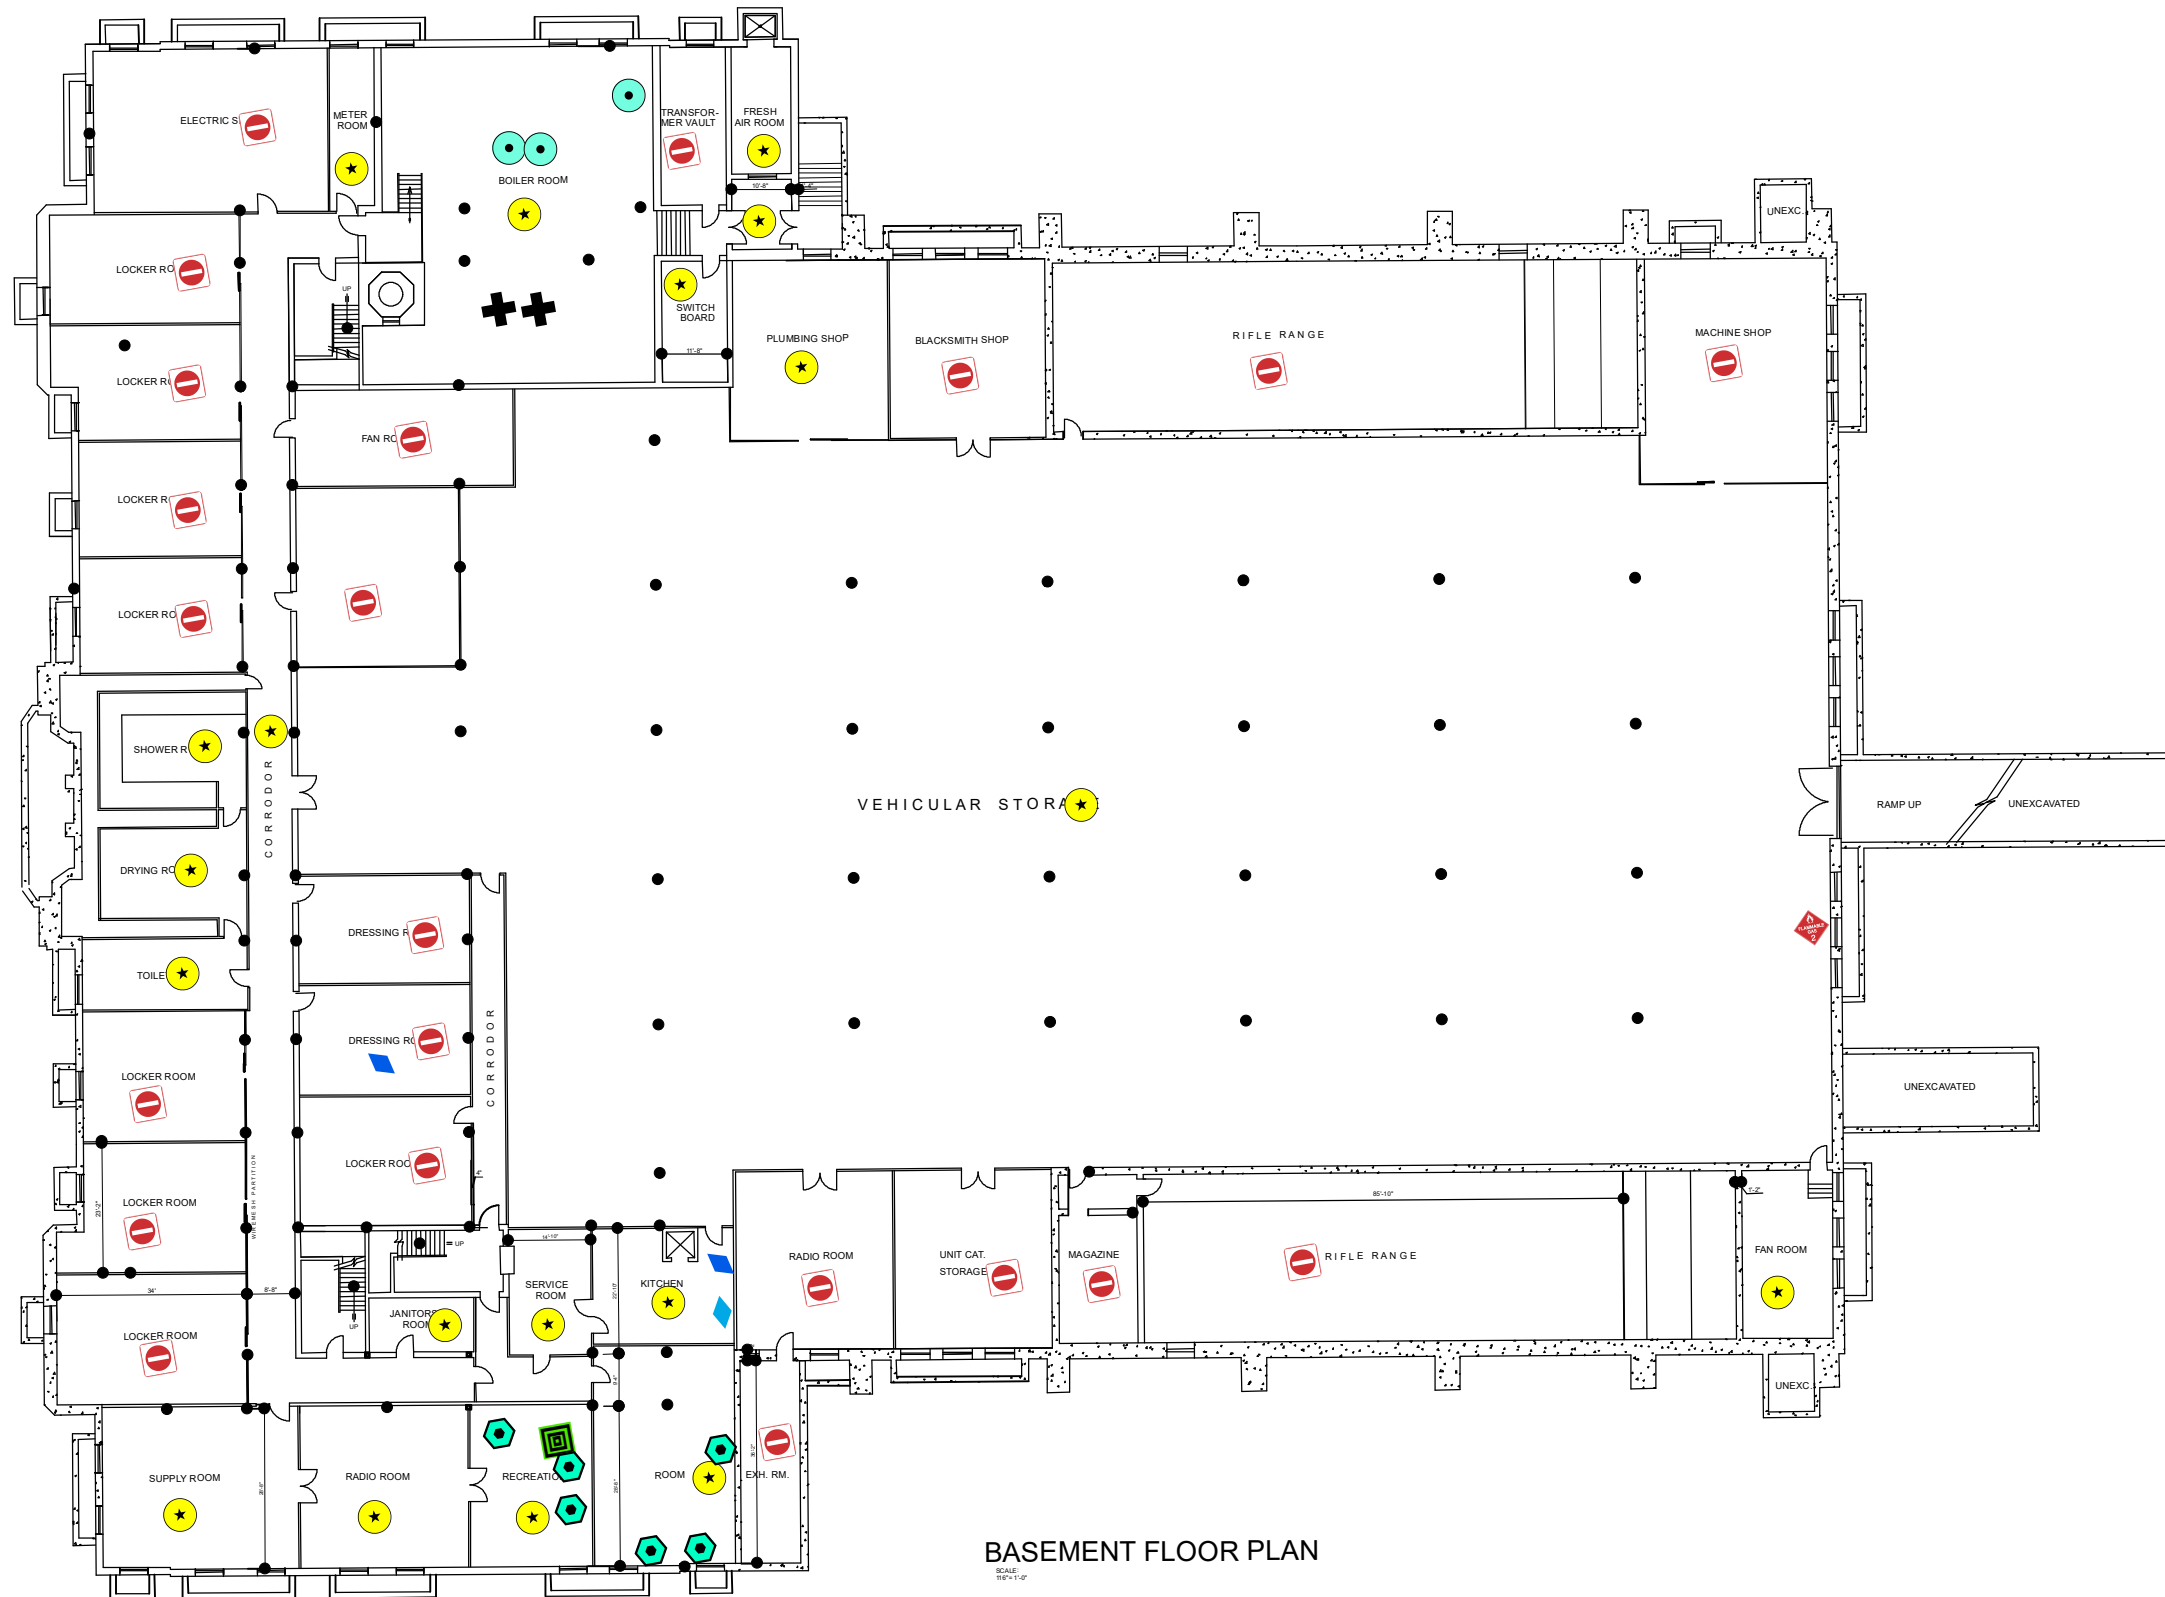




**Rowan
University
&
Stockton
University**

**Figure TK4
Site Map with
Site Level Features
Teaneck Armory
Basement**



Legend

Teaneck Armory Basement

-  Boiler
-  Chilled Serving Counter
-  Flammable Cabinet
-  Freezer Unit
-  Hot Water Heater
-  Ice Machine
-  Light Ballast
-  No Access
-  Refrigeration Unit

0 17.5 35 70 Feet

1 inch = 35 feet



Notes:


Floor plans georeferenced via headsup digitizing over 2015 aerial photography
Locations of air emissions, ODS, and FLBs georeferenced via floor plans



Scale: 1 inch = 35 feet
File: TK4
Date: 5/21/2019
Created By: Rosalie Hood,
Tim Ivancich,
Alexandria Petrosch





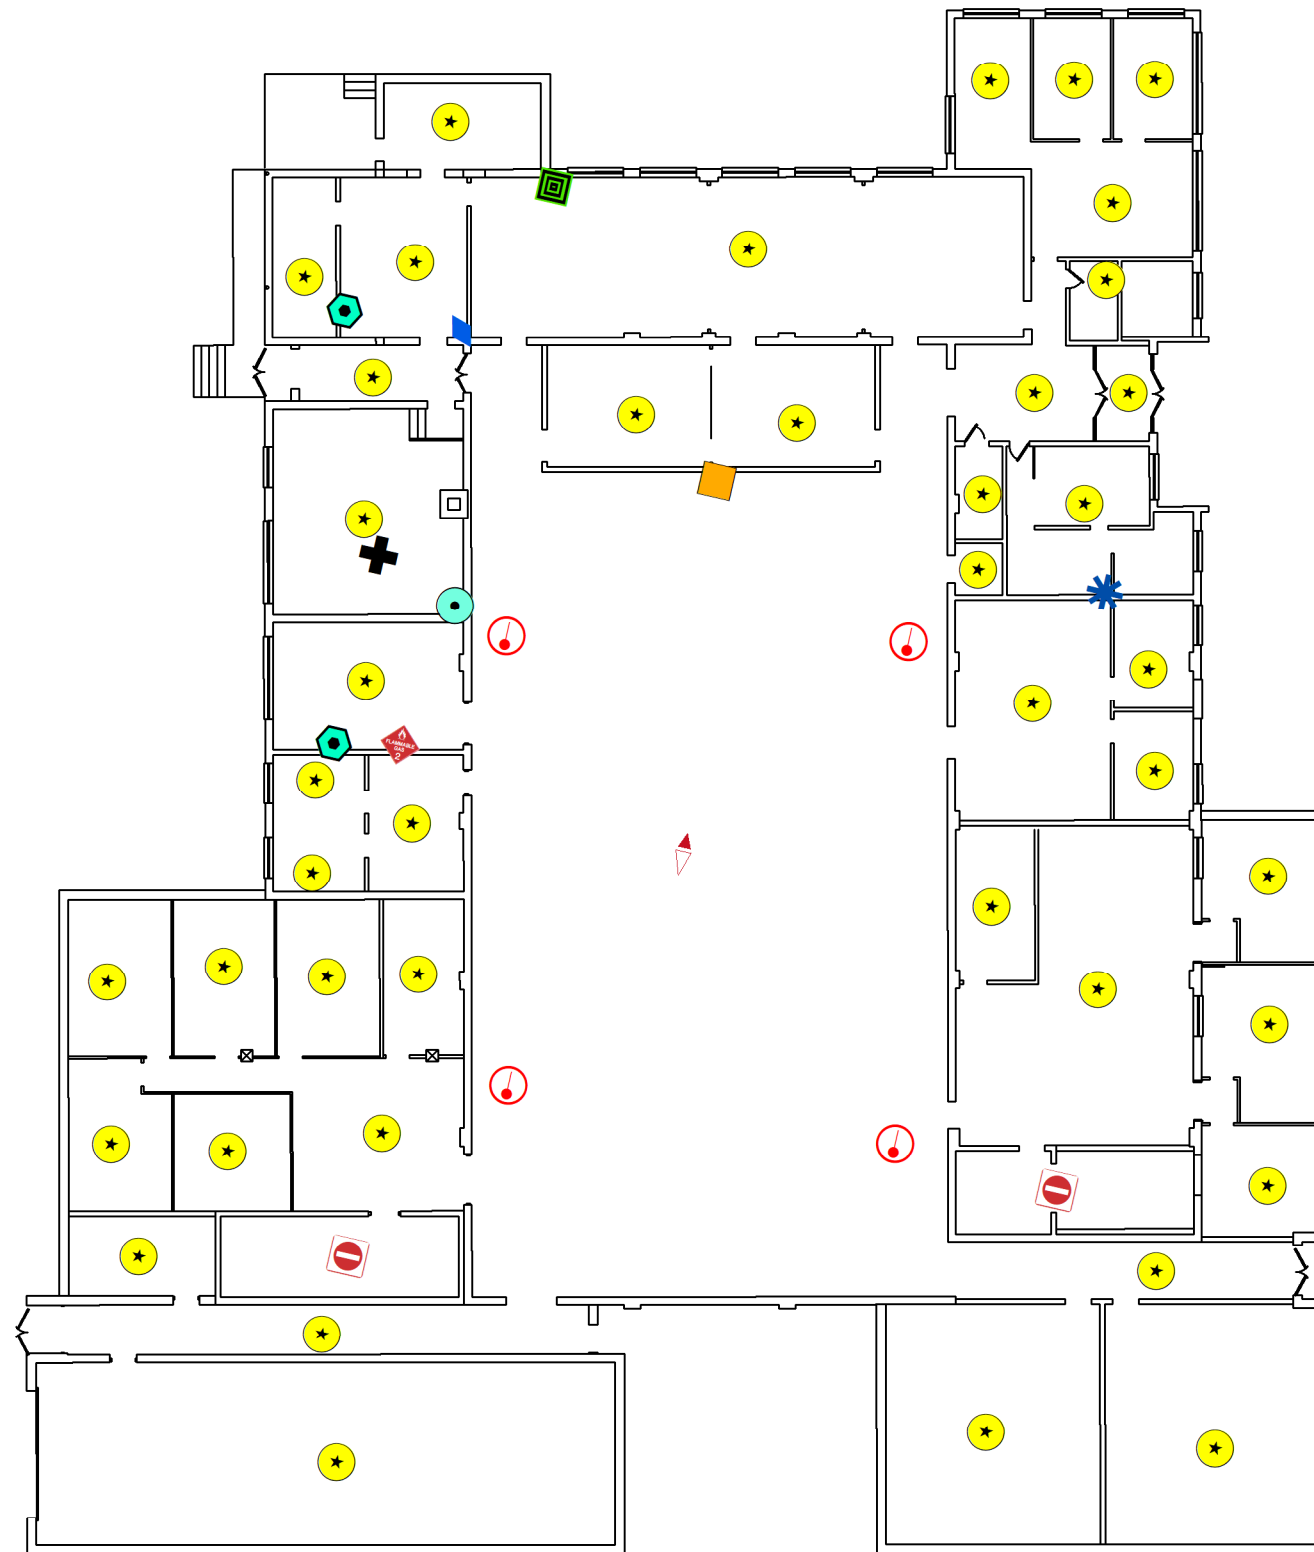







Rowan
University
&
Stockton
University


**Figure TR1
Site Map with
Site Level Features
Toms River Armory
Floor 1**



Legend

Toms River Armory 1st Floor

-  Air Conditioning Unit
-  Boiler
-  Chilled Serving Counter
-  Flammable Cabinet
-  Forced Air Heater
-  Hot Water Heater
-  Ice Machine
-  Light Ballast
-  No Access
-  No FLBs
-  Refrigeration Unit
-  Space Heater

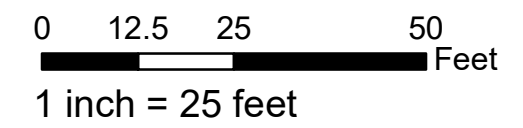

Notes:


Floor plans georeferenced via headsup digitizing over 2015 aerial photography
Locations of air emissions, ODS, and FLBs georeferenced via floor plans



Scale: 1 inch = 25 feet
File: TR1
Date: 5/21/2019
Created By: Jon McKinnon,
Michael Hoffman,
Alexandria Petros





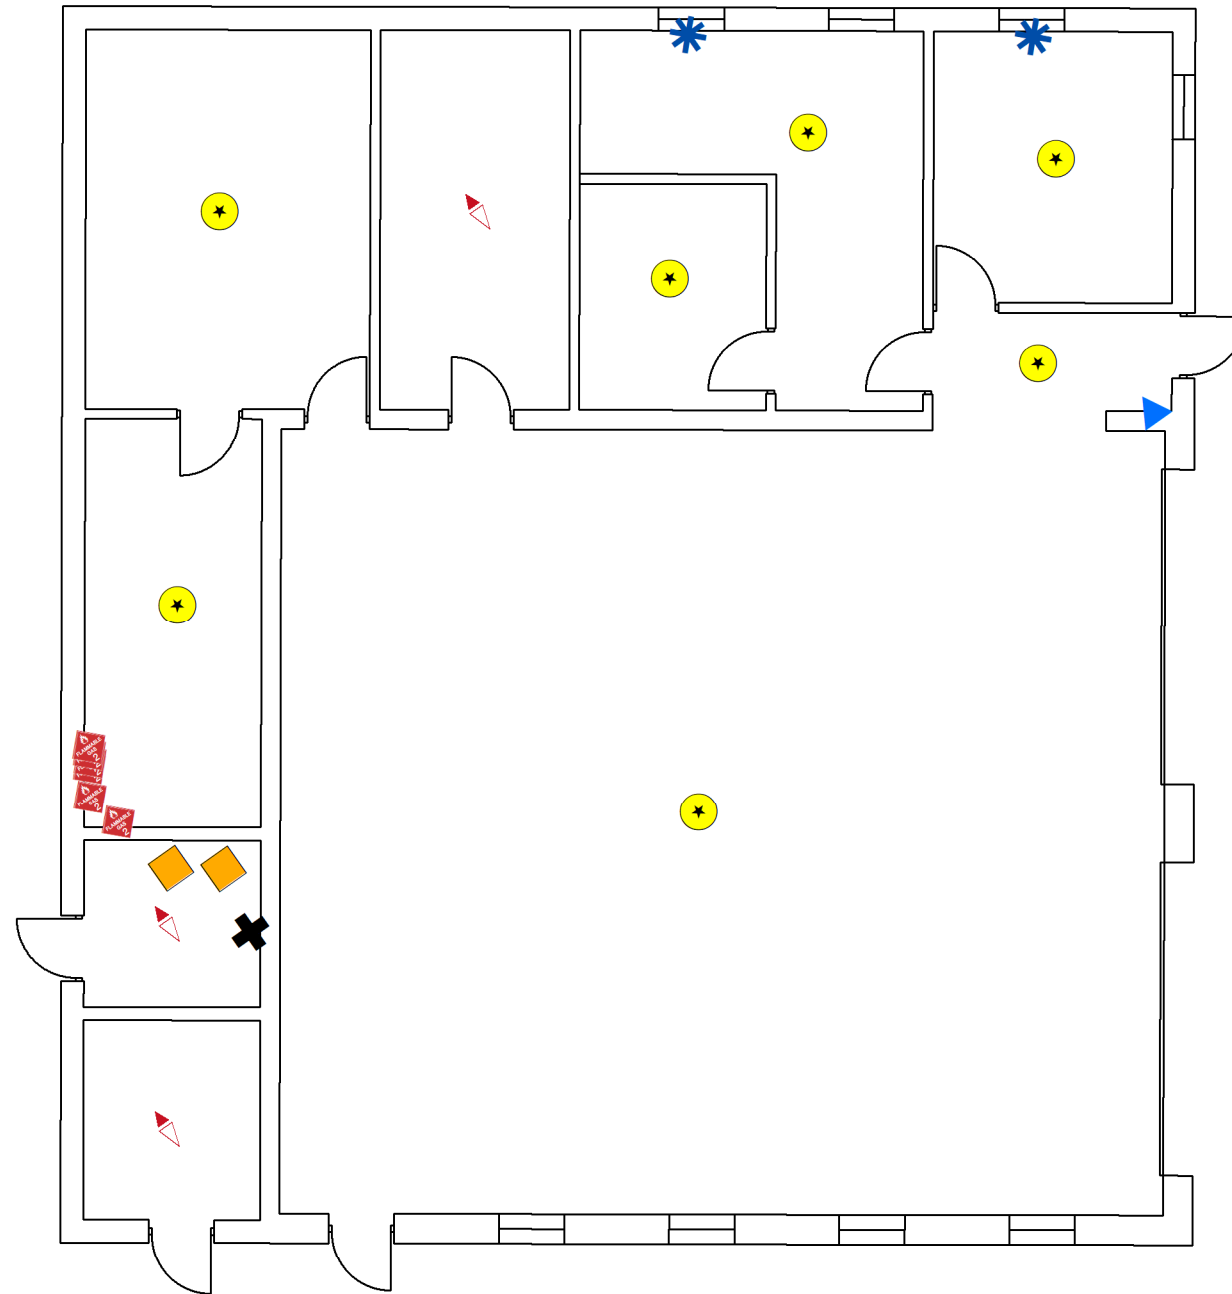


Rowan
University
&
Stockton
University

**Figure TR2
Site Map with
Site Level Features
Toms River MVSB
Floor 1**



Legend

Toms River MVSB 1st Floor

-  Air Conditioning Unit
-  Boiler
-  Drinking Water Fountain
-  Forced Air Heater
-  Light Ballast
-  Flammable Cabinet
-  No FLBs

0 5 10 20 Feet

1 inch = 10 feet



Notes:

Floor plans georeferenced via headsup digitizing over 2015 aerial photography
Locations of air emissions, ODS, and FLBs georeferenced via floor plans



Scale: 1 inch = 10 feet
File: TR2
Date: 5/21/2019
Created By: Jon McKinnon,
Tim Ivancich,
Alexandria Petrosch


**Rowan
University
&
Stockton
University**

**Figure TR3
Site Map with
Site Level Features
Toms River UTMB
Floor 1**

Legend

Toms River UTMB 1st Floor

 Forced Air Heater

 No FLBs

 Building_Outlines

0 5 10 20
Feet
1 inch = 10 feet



Notes:

Floor plans georeferenced via headsup digitizing
over 2015 aerial photography
Locations of air emissions, ODS, and FLBs georeferenced
via floor plans




Scale: 1 inch = 10 feet


File: TR3

Date: 5/21/2019

Created By: Jon McKinnon,
Michael Hoffman,
Alexandria Petrosch

**Rowan
University
&
Stockton
University**

 

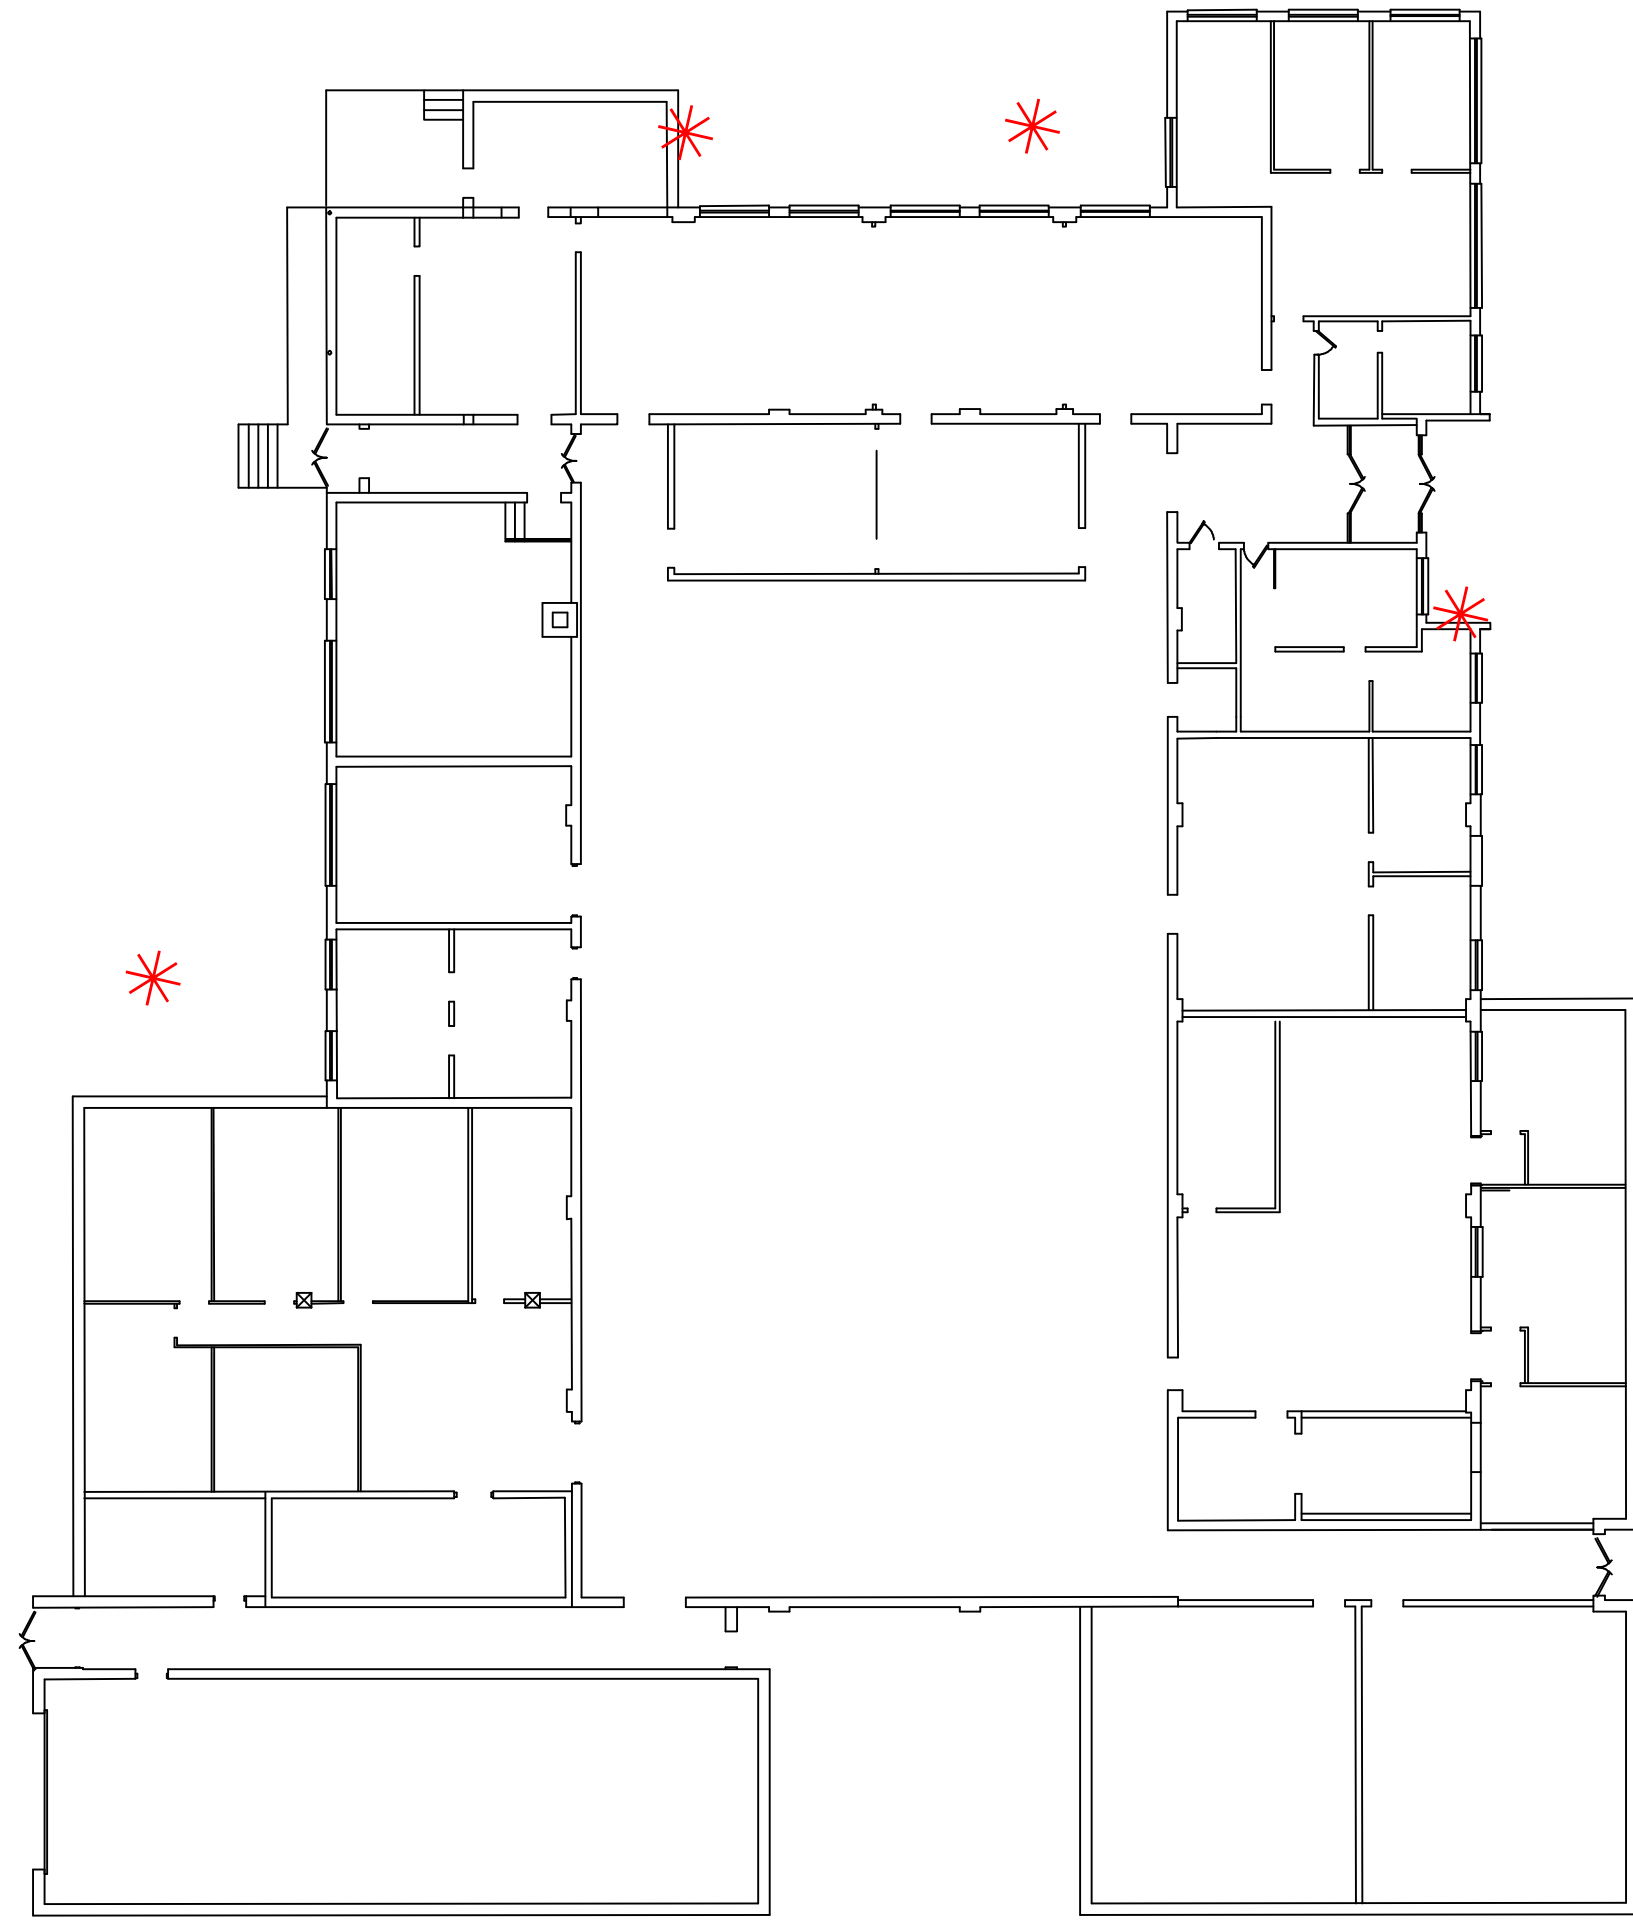


**Figure TR4
Site Map with
Site Level Features
Toms River Armory
Outside**

Legend

Toms River Outside Armory

 Air Conditioning Condenser Units

0 10 20 40 Feet
1 inch = 20 feet



Notes:


Floor plans georeferenced via headsup digitizing over 2015 aerial photography
Locations of air emissions, ODS, and FLBs georeferenced via floor plans



Scale: 1 inch = 20 feet
File: TR4
Date: 5/21/2019
Created By: Jon McKinnon,
Michael Hoffman,
Alexandria Petrosch



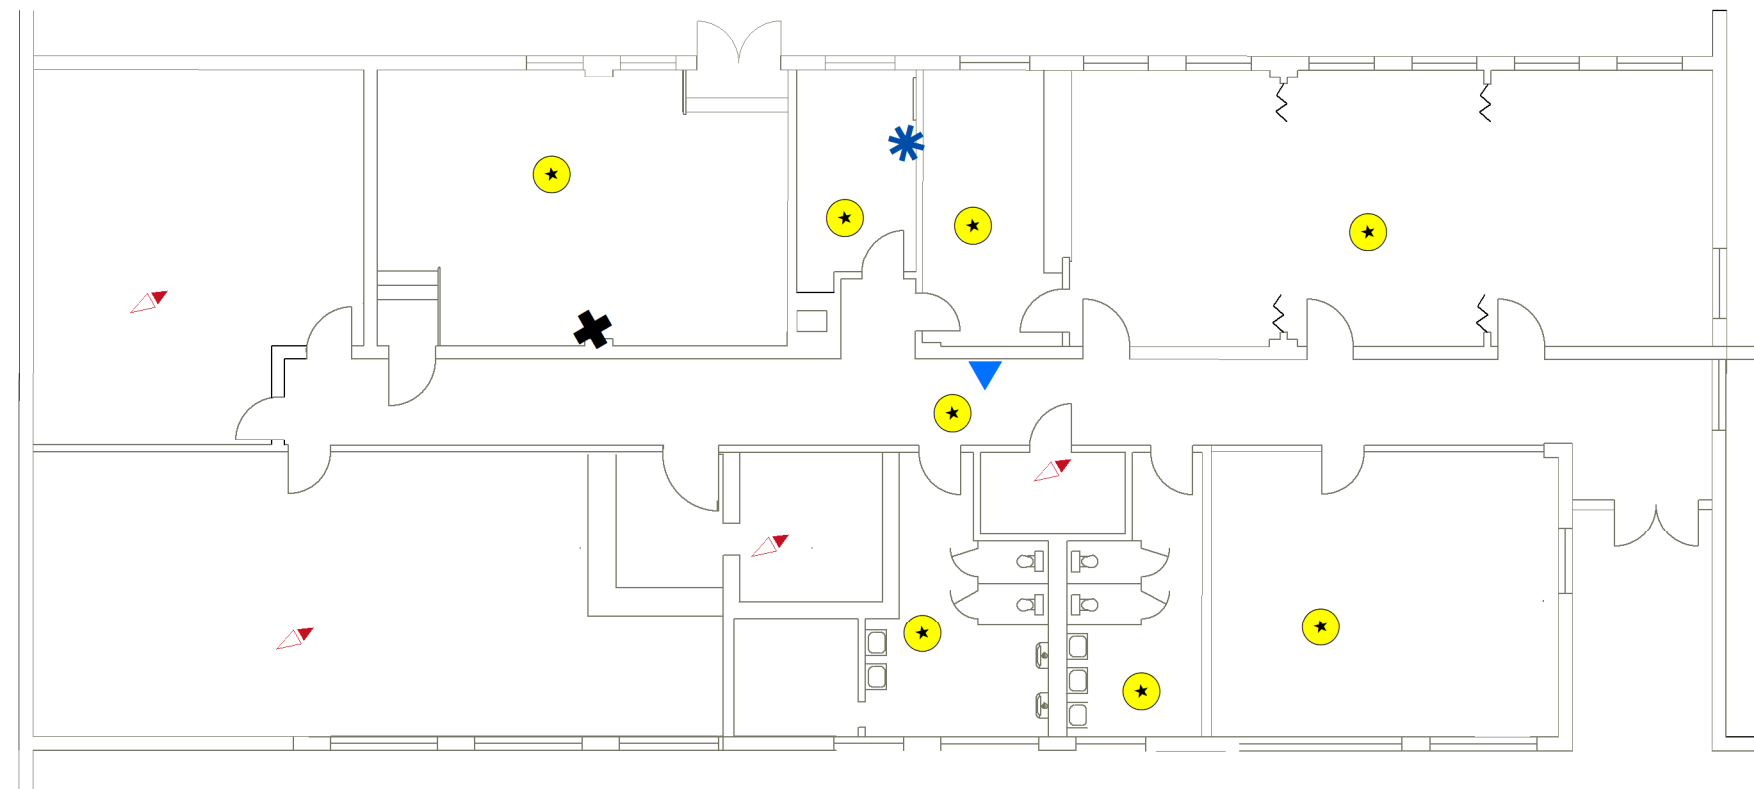


**Rowan
University
&
Stockton
University**

**Figure TN1
Site Map with
Site Level Features
Tuckerton Armory
Floor 1**



Legend

Tuckerton Armory 1st Floor

-  Air Conditioning Unit
-  Boiler
-  Drinking Water Fountain
-  No FLBs
-  Light Ballast



Notes:

Floor plans georeferenced via headsup digitizing over 2015 aerial photography
Locations of air emissions, ODS, and FLBs georeferenced via floor plans




Scale: 1 inch = 15 feet
File: TN1
Date: 5/21/2019
Created By: Jon McKinnon,
Michael Hoffman,
Alexandria Petros

**Rowan
University
&
Stockton
University**

**Figure TN2
Site Map with
Site Level Features
Tuckerton Armory
Floor 1**

 
Legend

Tuckerton MVSB 1st Floor

 No FLBs

0 7.5 15 30 Feet

1 inch = 15 feet



Notes:

Floor plans georeferenced via headsup digitizing
over 2015 aerial photography
Locations of air emissions, ODS, and FLBs georeferenced
via floor plans



Scale: 1 inch = 15 feet

File: TN2

Date: 5/21/2019

Created By: Jon McKinnon,
Alexandria Petrosch


**Rowan
University
&
Stockton
University**

**Figure TN3
Site Map with
Site Level Features
Tuckerton Armory
Outside**

Legend

Tuckerton Armory Outside

 Air Conditioning Unit

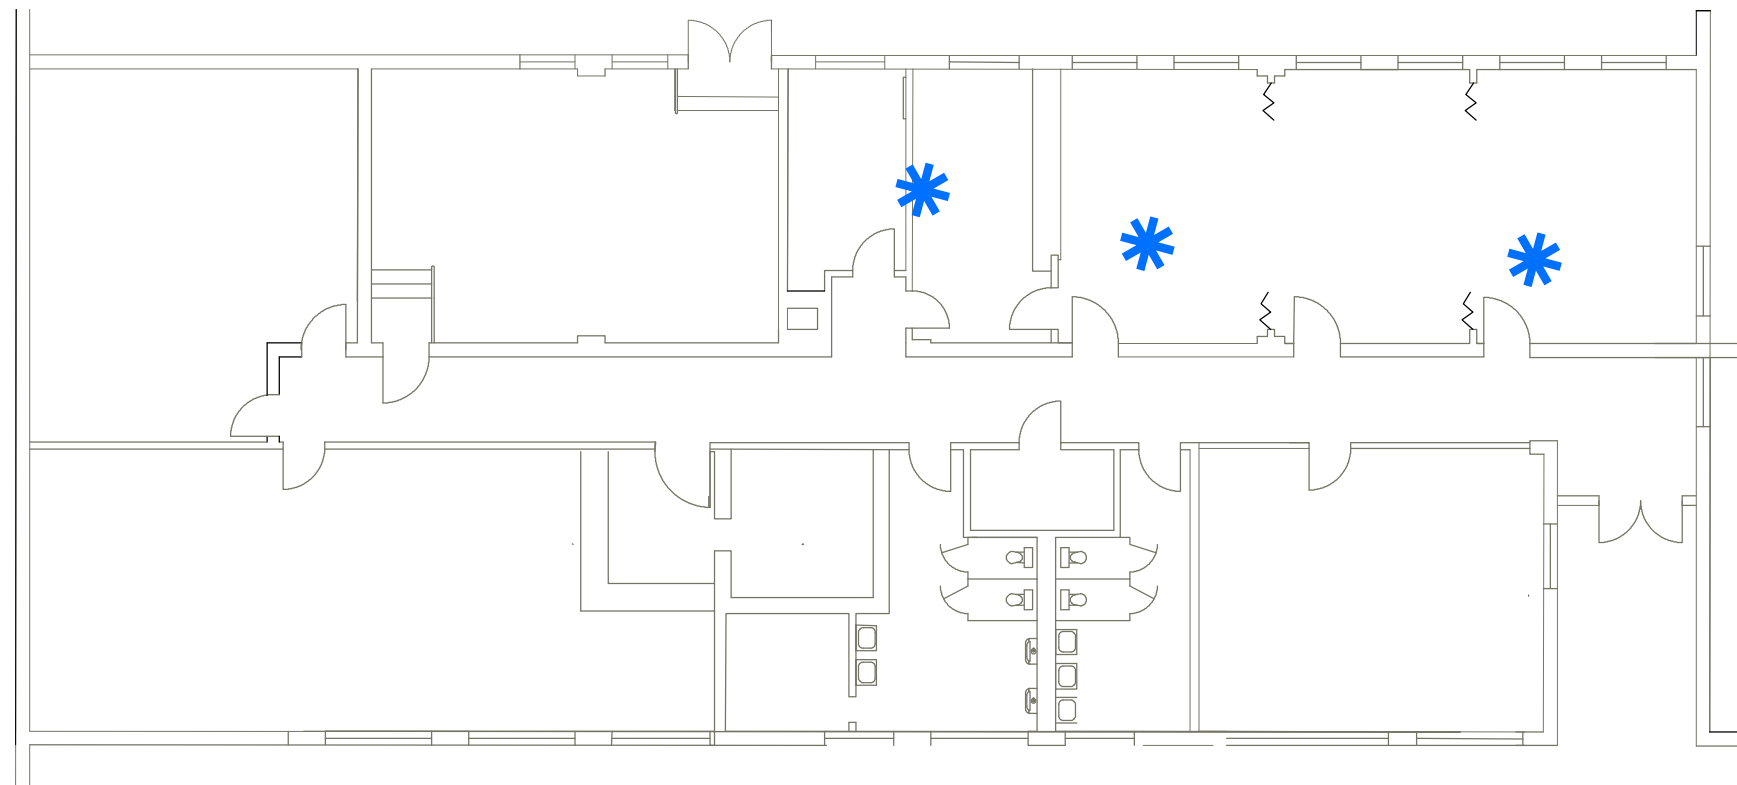

Notes:


Floor plans georeferenced via headsup digitizing over 2015 aerial photography
Locations of air emissions, ODS, and FLBs georeferenced via floor plans



Scale: 1 inch = 15 feet
File: TN3
Date: 5/21/2019
Created By: Jon McKinnon,
Michael Hoffman,
Alexandria Petrosch



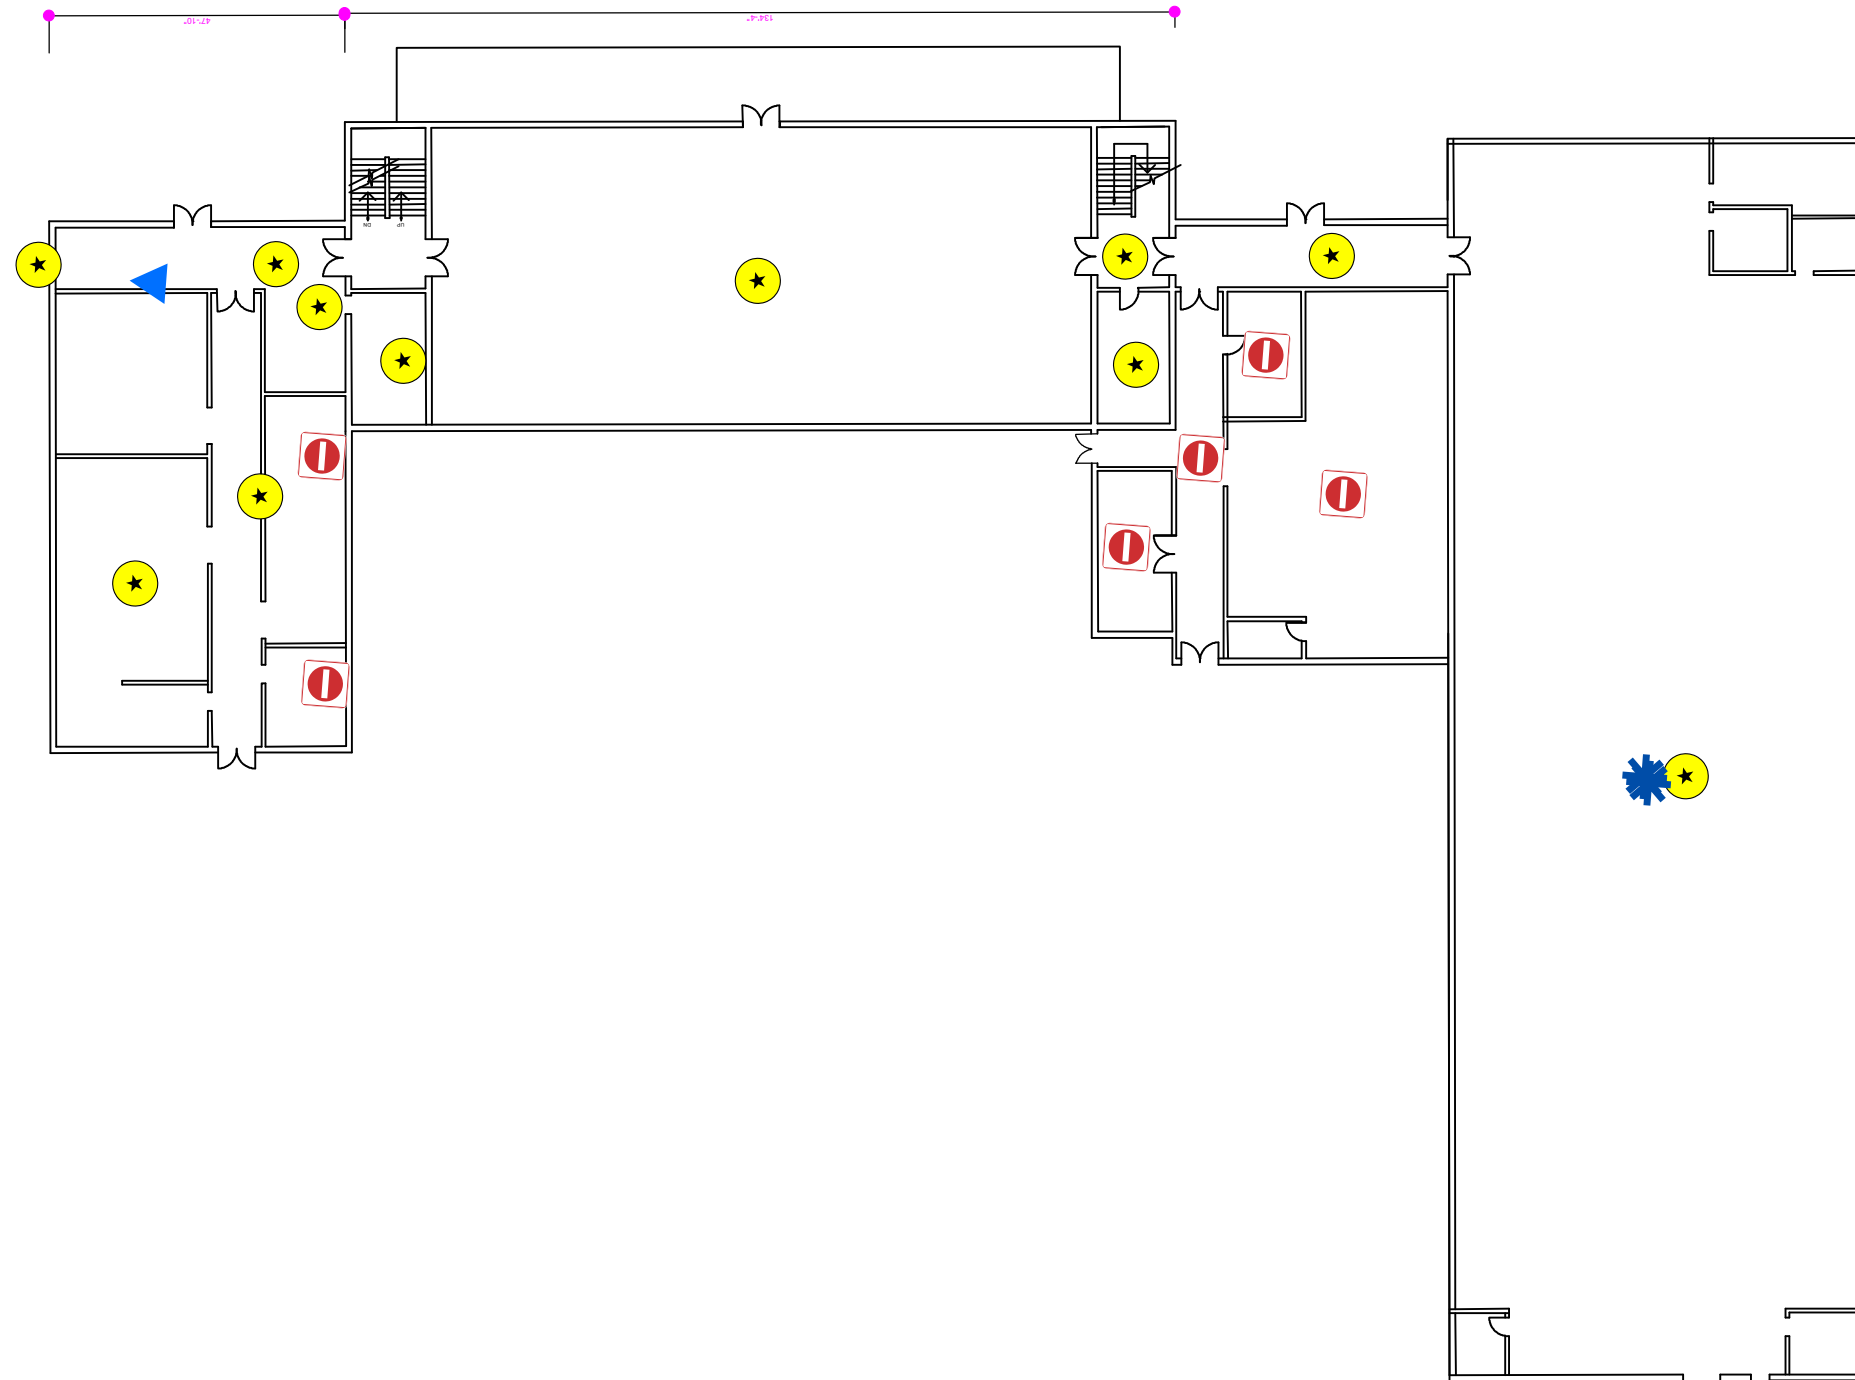


**Rowan
University
&
Stockton
University**

**Figure VD1
Site Map with
Site Level Features
Vineland Armory
Floor 1**



Legend

Vineland Armory 1st Floor

-  Air Conditioning Unit
-  Drinking Water Fountain
-  Hot Water Heater
-  Light Ballast
-  No Access



1 inch = 30 feet

Notes:


Floor plans georeferenced via headsup digitizing over 2015 aerial photography
Locations of air emissions, ODS, and FLBs georeferenced via floor plans



Scale: 1 inch = 30 feet
File: VD1
Date: 5/21/2019
Created By: Rosalie Hood,
Tim Ivancich,
Alexandria Petrosch



**Rowan
University
&
Stockton
University**

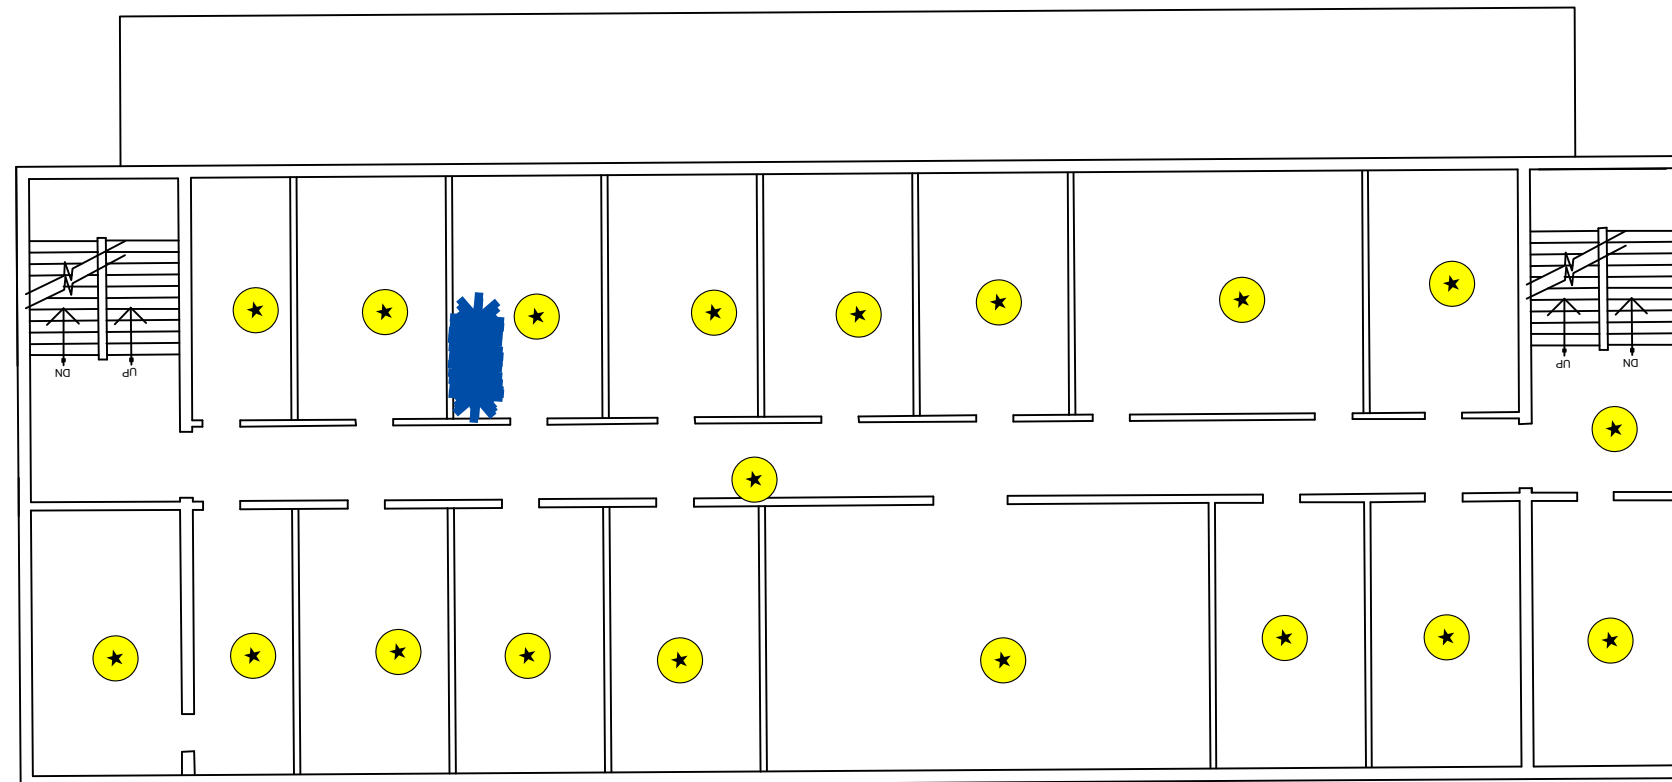**Figure VD2
Site Map with
Site Level Features
Vineland Army
Floor 2**



Legend

Vineland Army 2nd Floor

-  Air Conditioning Unit
-  Light Ballast

0 7.5 15 30
Feet

1 inch = 15 feet



Notes:


Floor plans georeferenced via headsup digitizing over 2015 aerial photography
Locations of air emissions, ODS, and FLBs georeferenced via floor plans



Scale: 1 inch = 15 feet
File: VD2
Date: 5/21/2019
Created By: Rosalie Hood,
Tim Ivancich,
Alexandria Petrosch



**Rowan
University
&
Stockton
University**

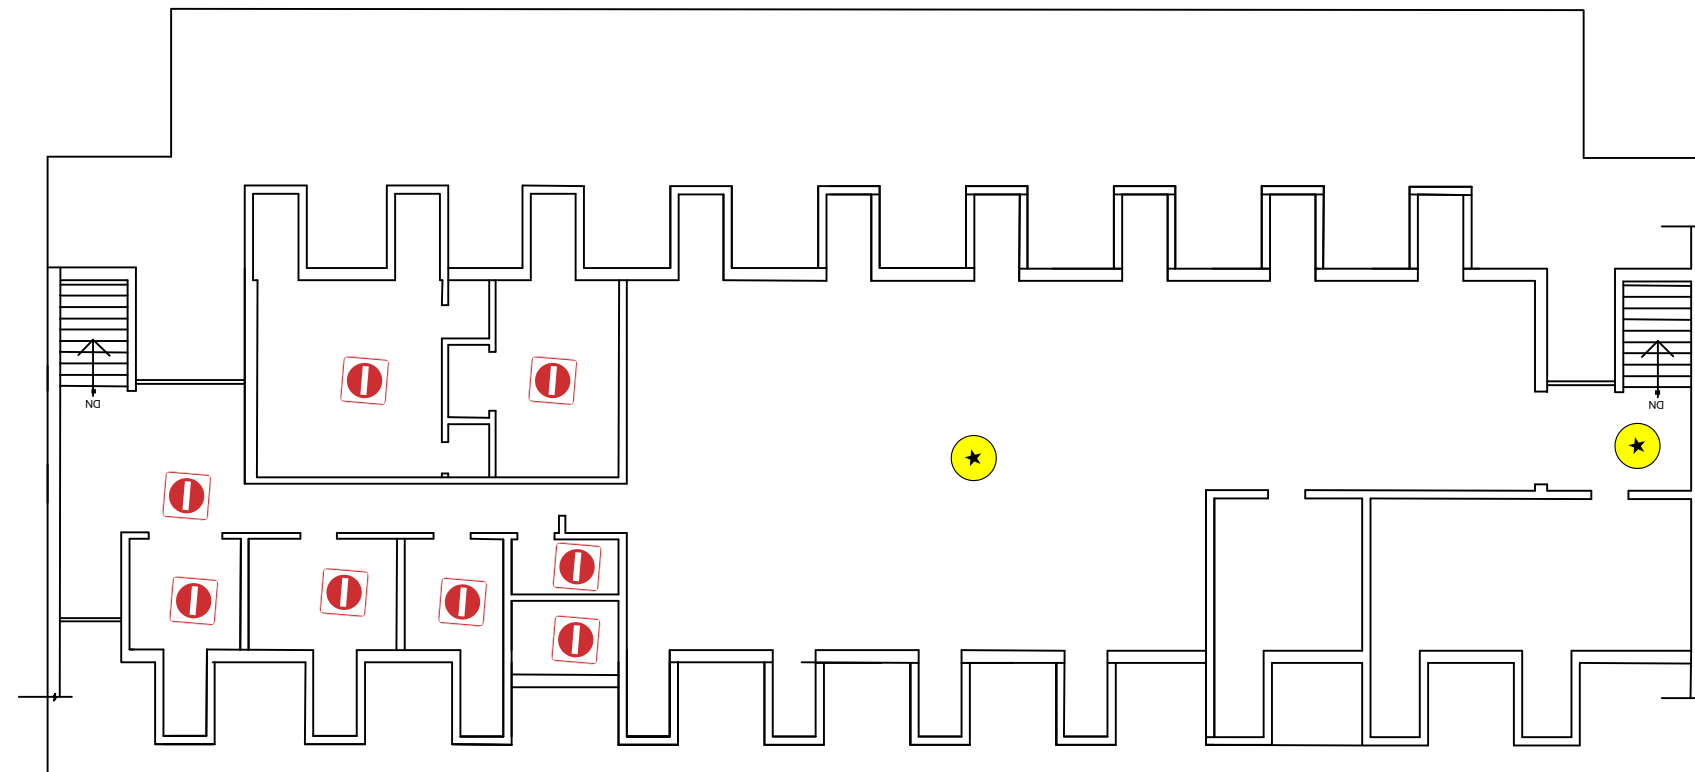**Figure VD3
Site Map with
Site Level Features
Vineland Armory
Floor 3**



Legend

Vineland_Armory Floor 3

-  Light Ballast
-  No Access

0 7.5 15 30
Feet

1 inch = 15 feet



Notes:


Floor plans georeferenced via headsup digitizing over 2015 aerial photography
Locations of air emissions, ODS, and FLBs georeferenced via floor plans



Scale: 1 inch = 15 feet
File: VD3
Date: 5/21/2019
Created By: Rosalie Hood,
Tim Ivancich,
Alexandria Petrosch





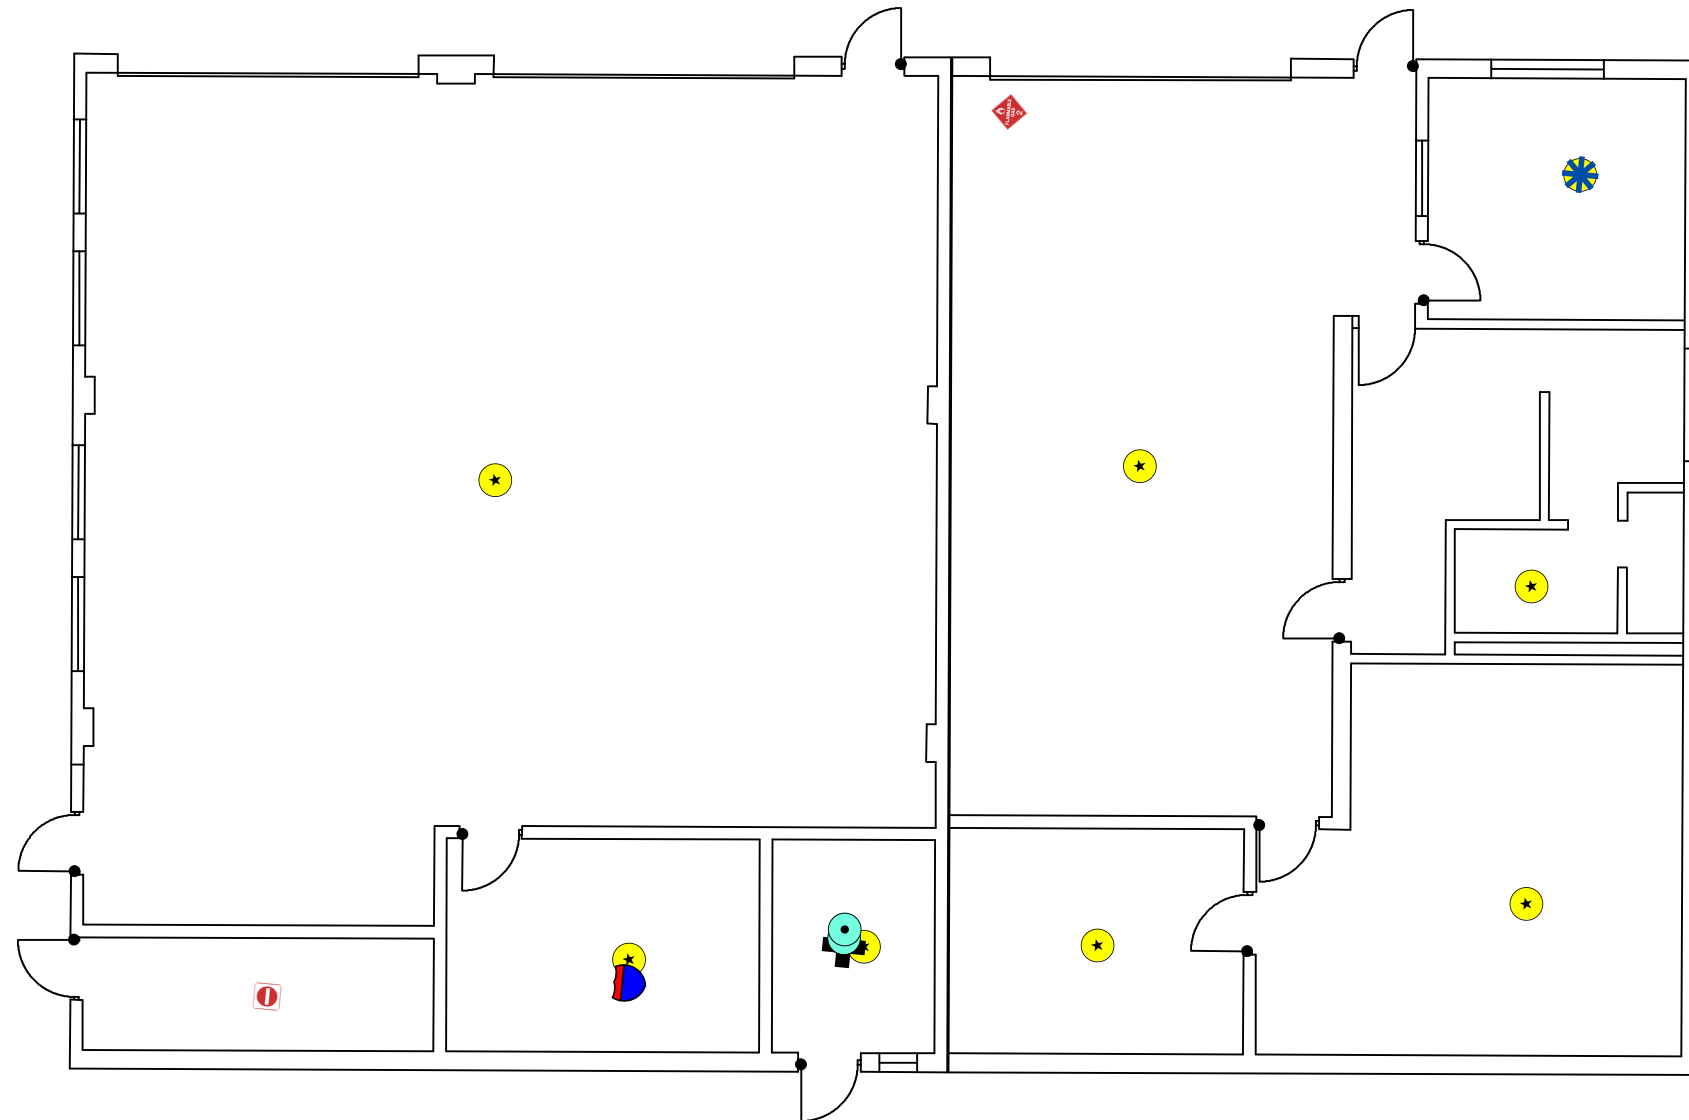






**Rowan
University
&
Stockton
University**


**Figure VD4
Site Map with
Site Level Features
Vineland OMS
Floor 1**



Legend

Vineland OMS 1st Floor

-  Air Conditioning Unit
-  Boiler
-  Drinking Water Fountain
-  Flammable Cabinet
-  Hot Water Heater
-  Light Ballast
-  No Access
-  Parts Washer
-  Refrigeration Unit
-  Storage Tank
-  Vehicle Recovery Air Conditioning Unit

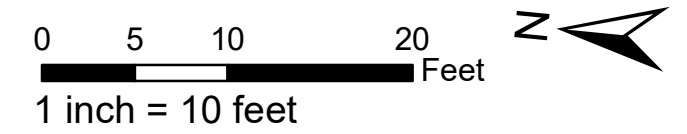

Notes:

Floor plans georeferenced via headsup digitizing over 2015 aerial photography
Locations of air emissions, ODS, and FLBs georeferenced via floor plans







Scale: 1 inch = 10 feet
File: VD4
Date: 5/21/2019
Created By: Rosalie Hood,
Tim Ivancich,
Alexandria Petrosch

**Rowan
University
&
Stockton
University**

**Figure VD5
Site Map with
Site Level Features
Vineland Armory
Basement**


Legend

Vineland Armory Basement

-  Air Conditioning Unit
-  Ice Machine
-  Light Ballast
-  Refrigeration Unit

0 5 10 20 Feet

1 inch = 10 feet

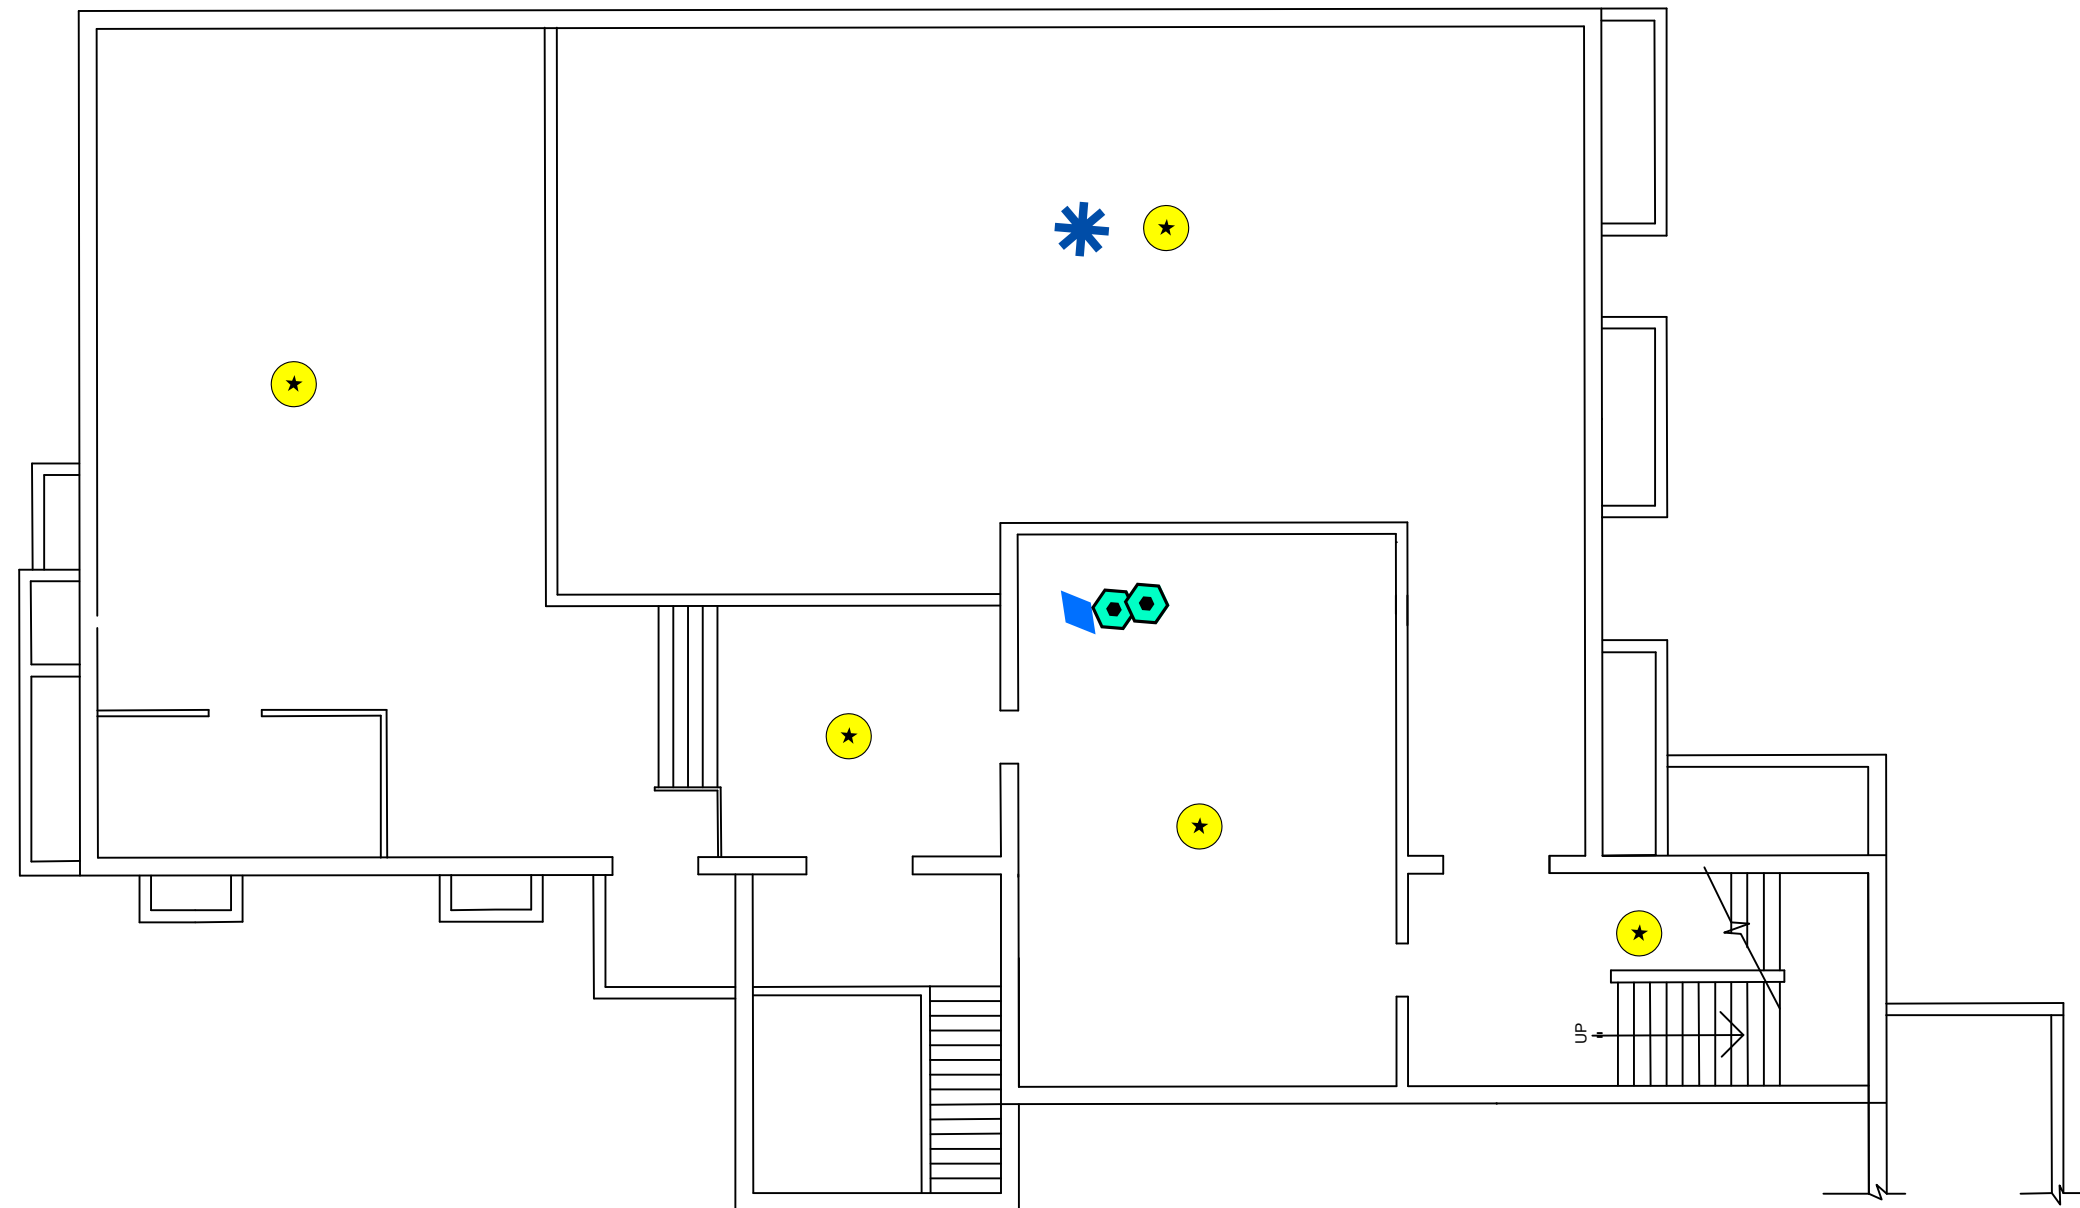

Notes:


Floor plans georeferenced via headsup digitizing over 2015 aerial photography
Locations of air emissions, ODS, and FLBs georeferenced via floor plans



Scale: 1 inch = 10 feet
File: VD5
Date: 5/21/2019
Created By: Rosalie Hood,
Tim Ivancich,
Alexandria Petrosch

**Rowan
University
&
Stockton
University**

**Figure VD6
Site Map with
Site Level Features
Vineland Armory
Outside**

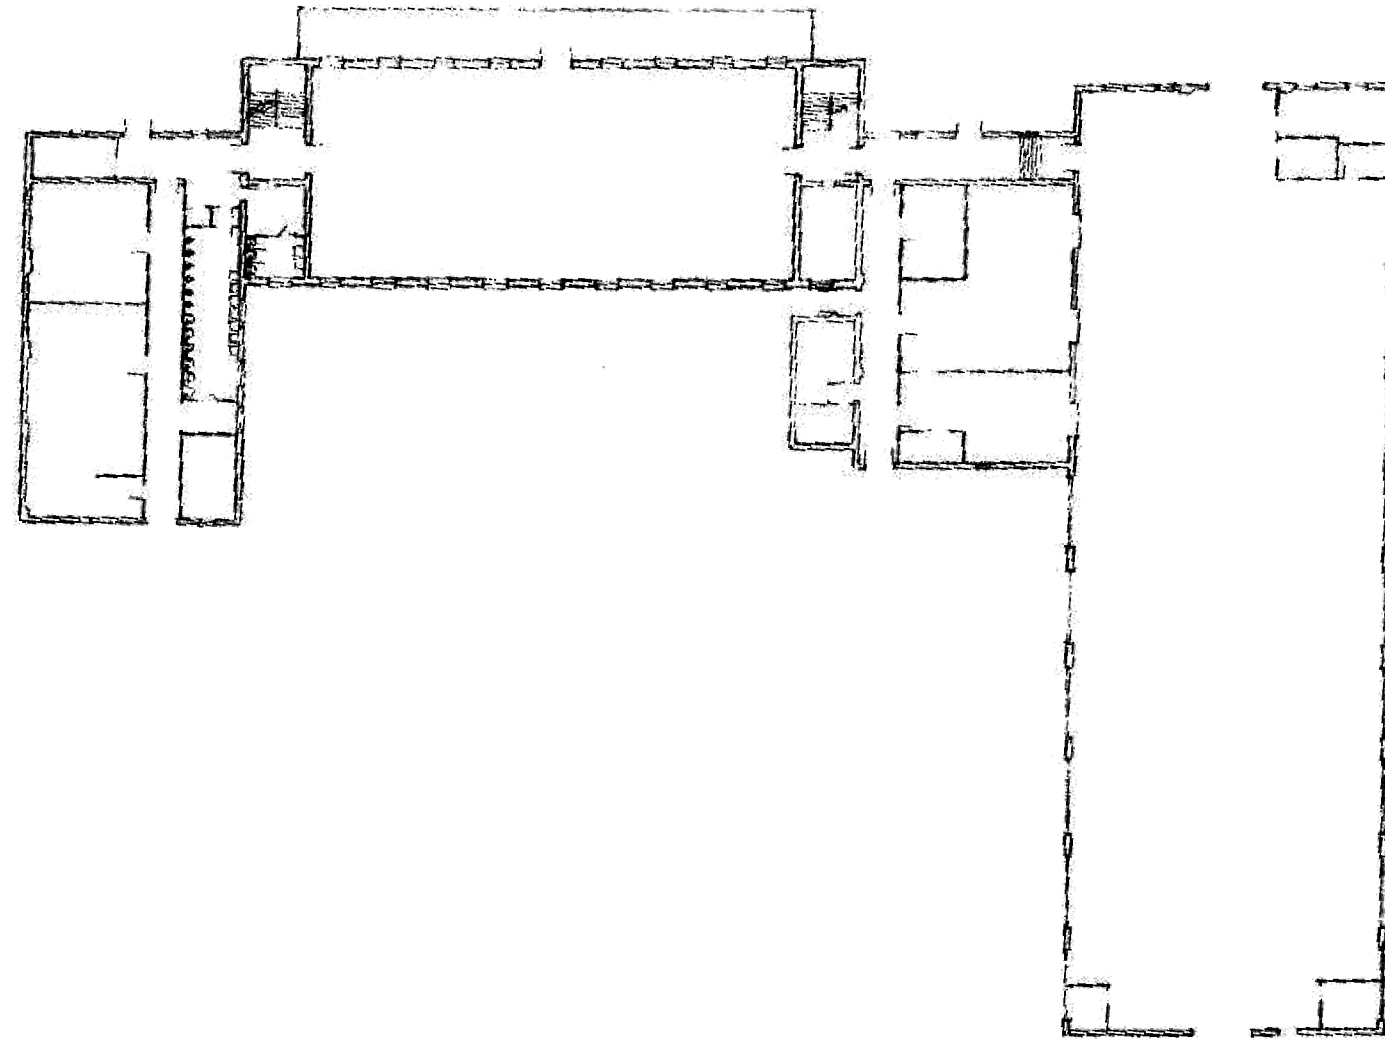

Legend

Vineland Armory Outside

■ Storage Tank

0 20 40 80 Feet

1 inch = 40 feet



Notes:

Floor plans georeferenced via headsup digitizing over 2015 aerial photography
Locations of air emissions, ODS, and FLBs georeferenced via floor plans



Scale: 1 inch = 40 feet


File: VD6

Date: 5/21/2019

Created By: Rosalie Hood,
Michael Hoffman,
Alexandria Petrosch





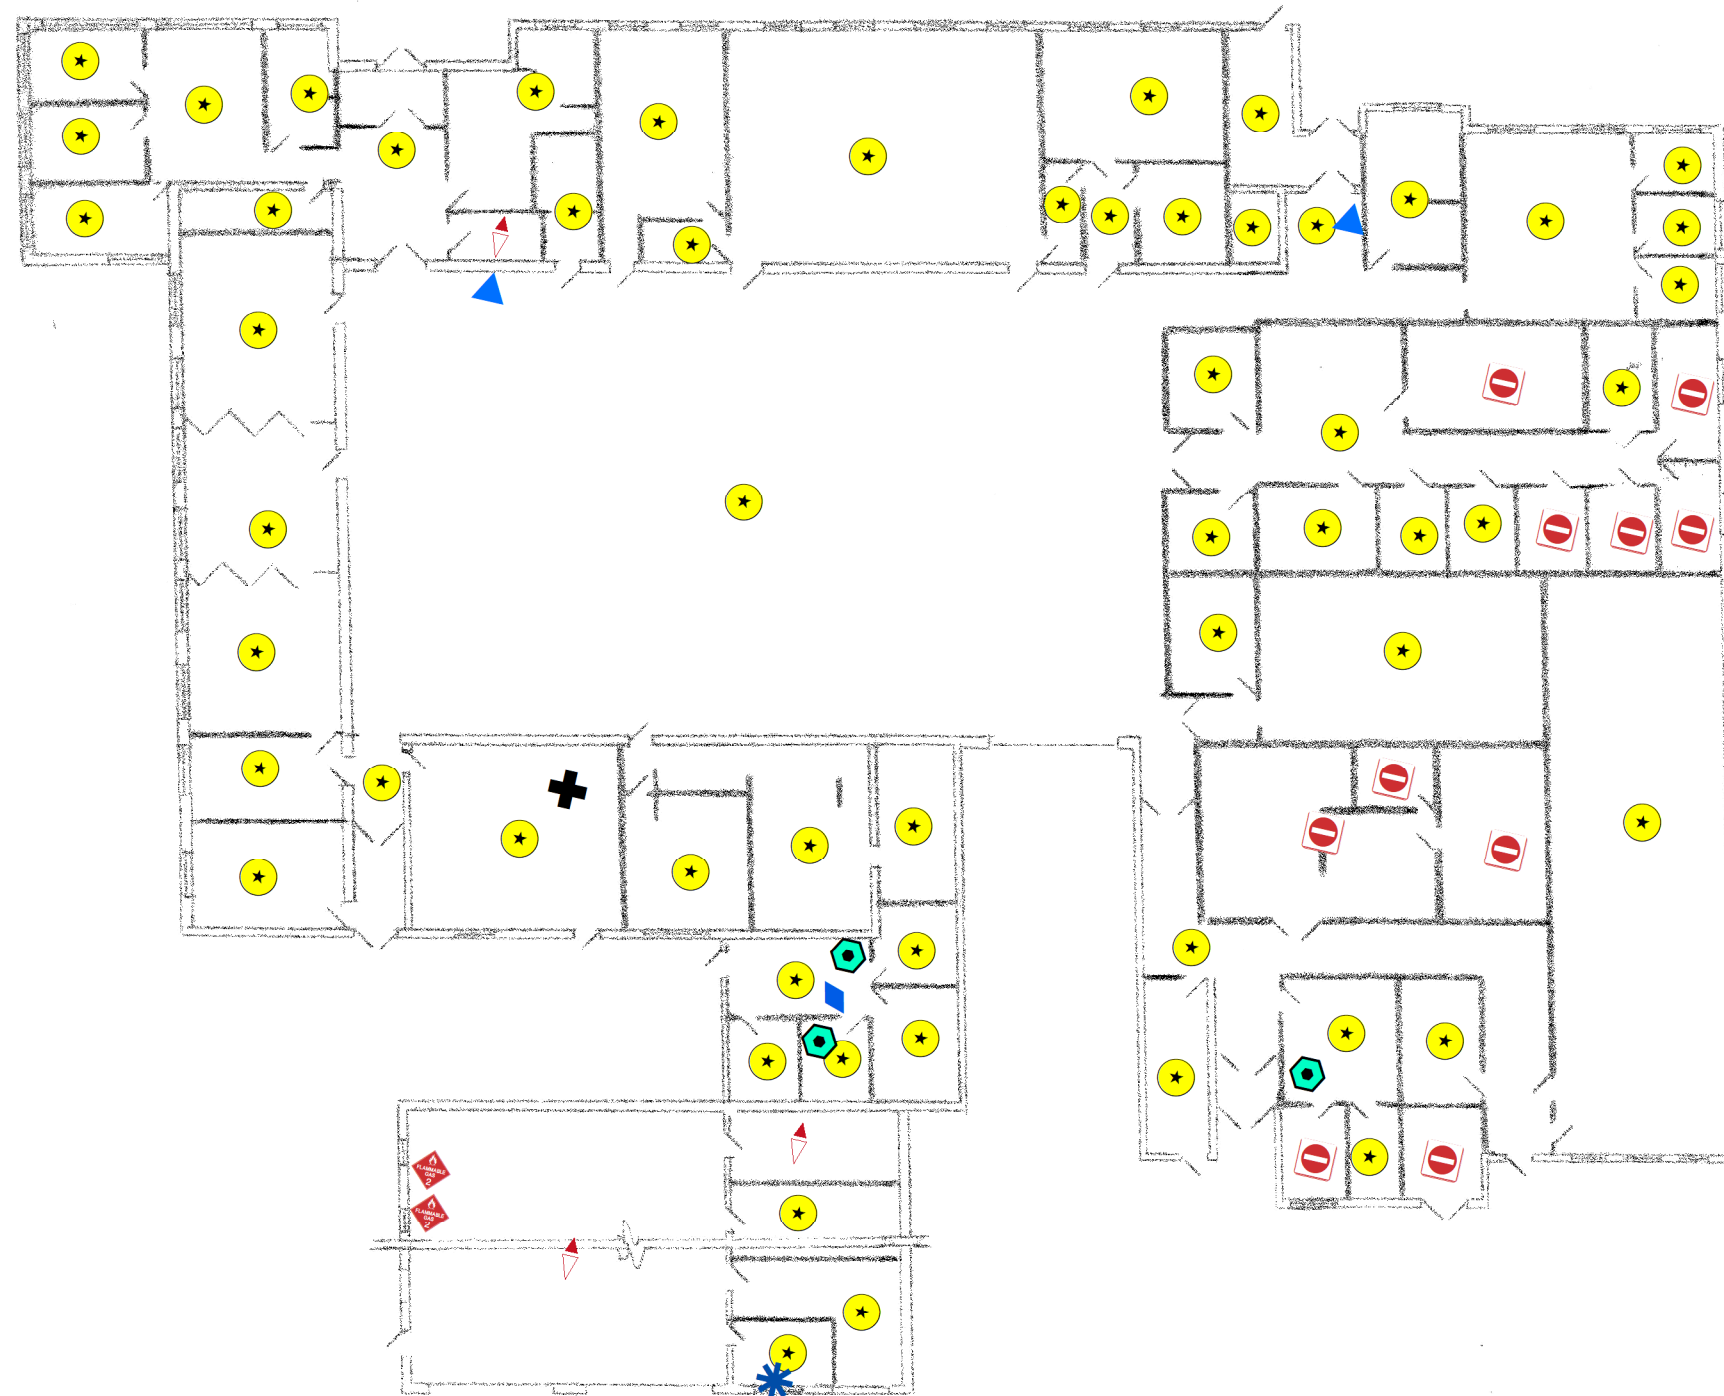




**Rowan
University
&
Stockton
University**

**Figure WT1
Site Map with
Site Level Features
Washington Armory
Floor 1**



Legend

Washington Armory 1st Floor

-  Air Conditioning Unit
-  Boiler
-  Drinking Water Fountain
-  Flammable Cabinet
-  Ice Machine
-  Light Ballast
-  No Access
-  No FLBs
-  Refrigeration Unit

0 12.5 25 50 Feet
1 inch = 25 feet



Notes:

Floor plans georeferenced via headsup digitizing over 2015 aerial photography
Locations of air emissions, ODS, and FLBs georeferenced via floor plans







Scale: 1 inch = 25 feet
File: WT1
Date: 5/21/2019
Created By: Rosalie Hood
Anne Timmreck,
Raina Ryan,
Alexandria Petrosch

**Rowan
University
&
Stockton
University**

**Figure WT2
Site Map with
Site Level Features
Washington Armory
Floor 2**

Legend

Washington Armory 2nd Floor

-  Air Conditioning Unit
-  Drinking Water Fountain
-  Light Ballast
-  No Access

0 7.5 15 30
Feet

1 inch = 15 feet



Notes:

Floor plans georeferenced via headsup digitizing over 2015 aerial photography
Locations of air emissions, ODS, and FLBs georeferenced via floor plans



Scale: 1 inch = 15 feet


File: WT2

Date: 5/21/2019

Created By: Rosalie Hood,
Anne Timmreck,
Raina Ryan,
Alexandria Petrosch





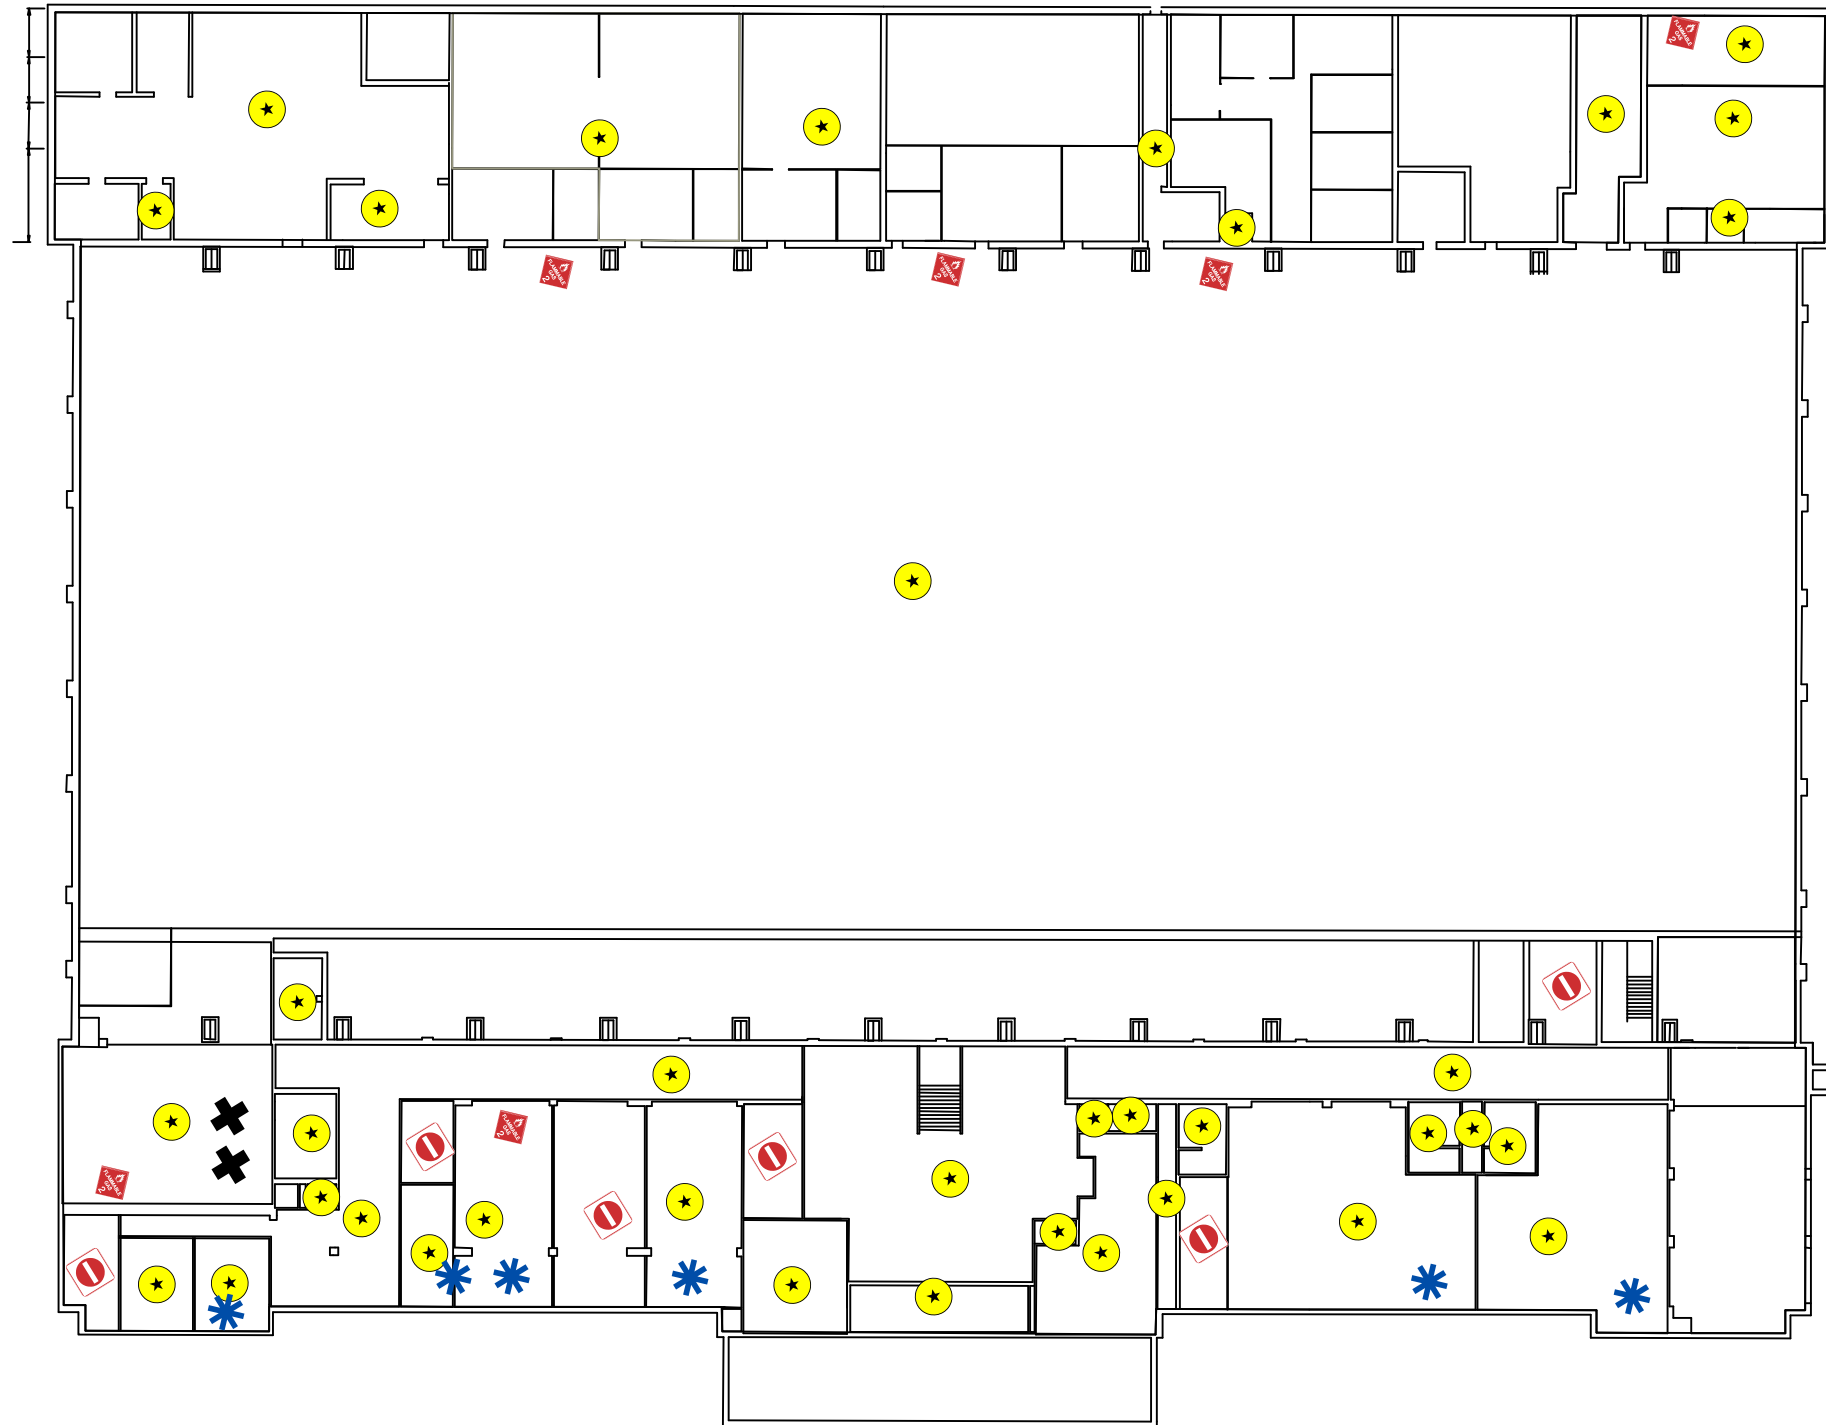

**Rowan
University
&
Stockton
University**

**Figure WO1
Site Map with
Site Level Features
West Orange Armory
Floor 1**




Legend

West Orange Armory 1st Floor

-  Air Conditioning Unit
-  Boiler
-  Drinking Water Fountain
-  Flammable Cabinet
-  No Access
-  Light Ballast

0 17.5 35 70 Feet

1 inch = 35 feet

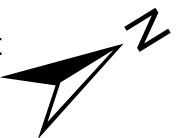

Notes:


Floor plans georeferenced via headsup digitizing over 2015 aerial photography
Locations of air emissions, ODS, and FLBs georeferenced via floor plans



Scale: 1 inch = 35 feet
File: WO1
Date: 5/21/2019
Created By: Rosalie Hood
Anne Timmreck,
Raina Ryan,
Alexandria Petrosch





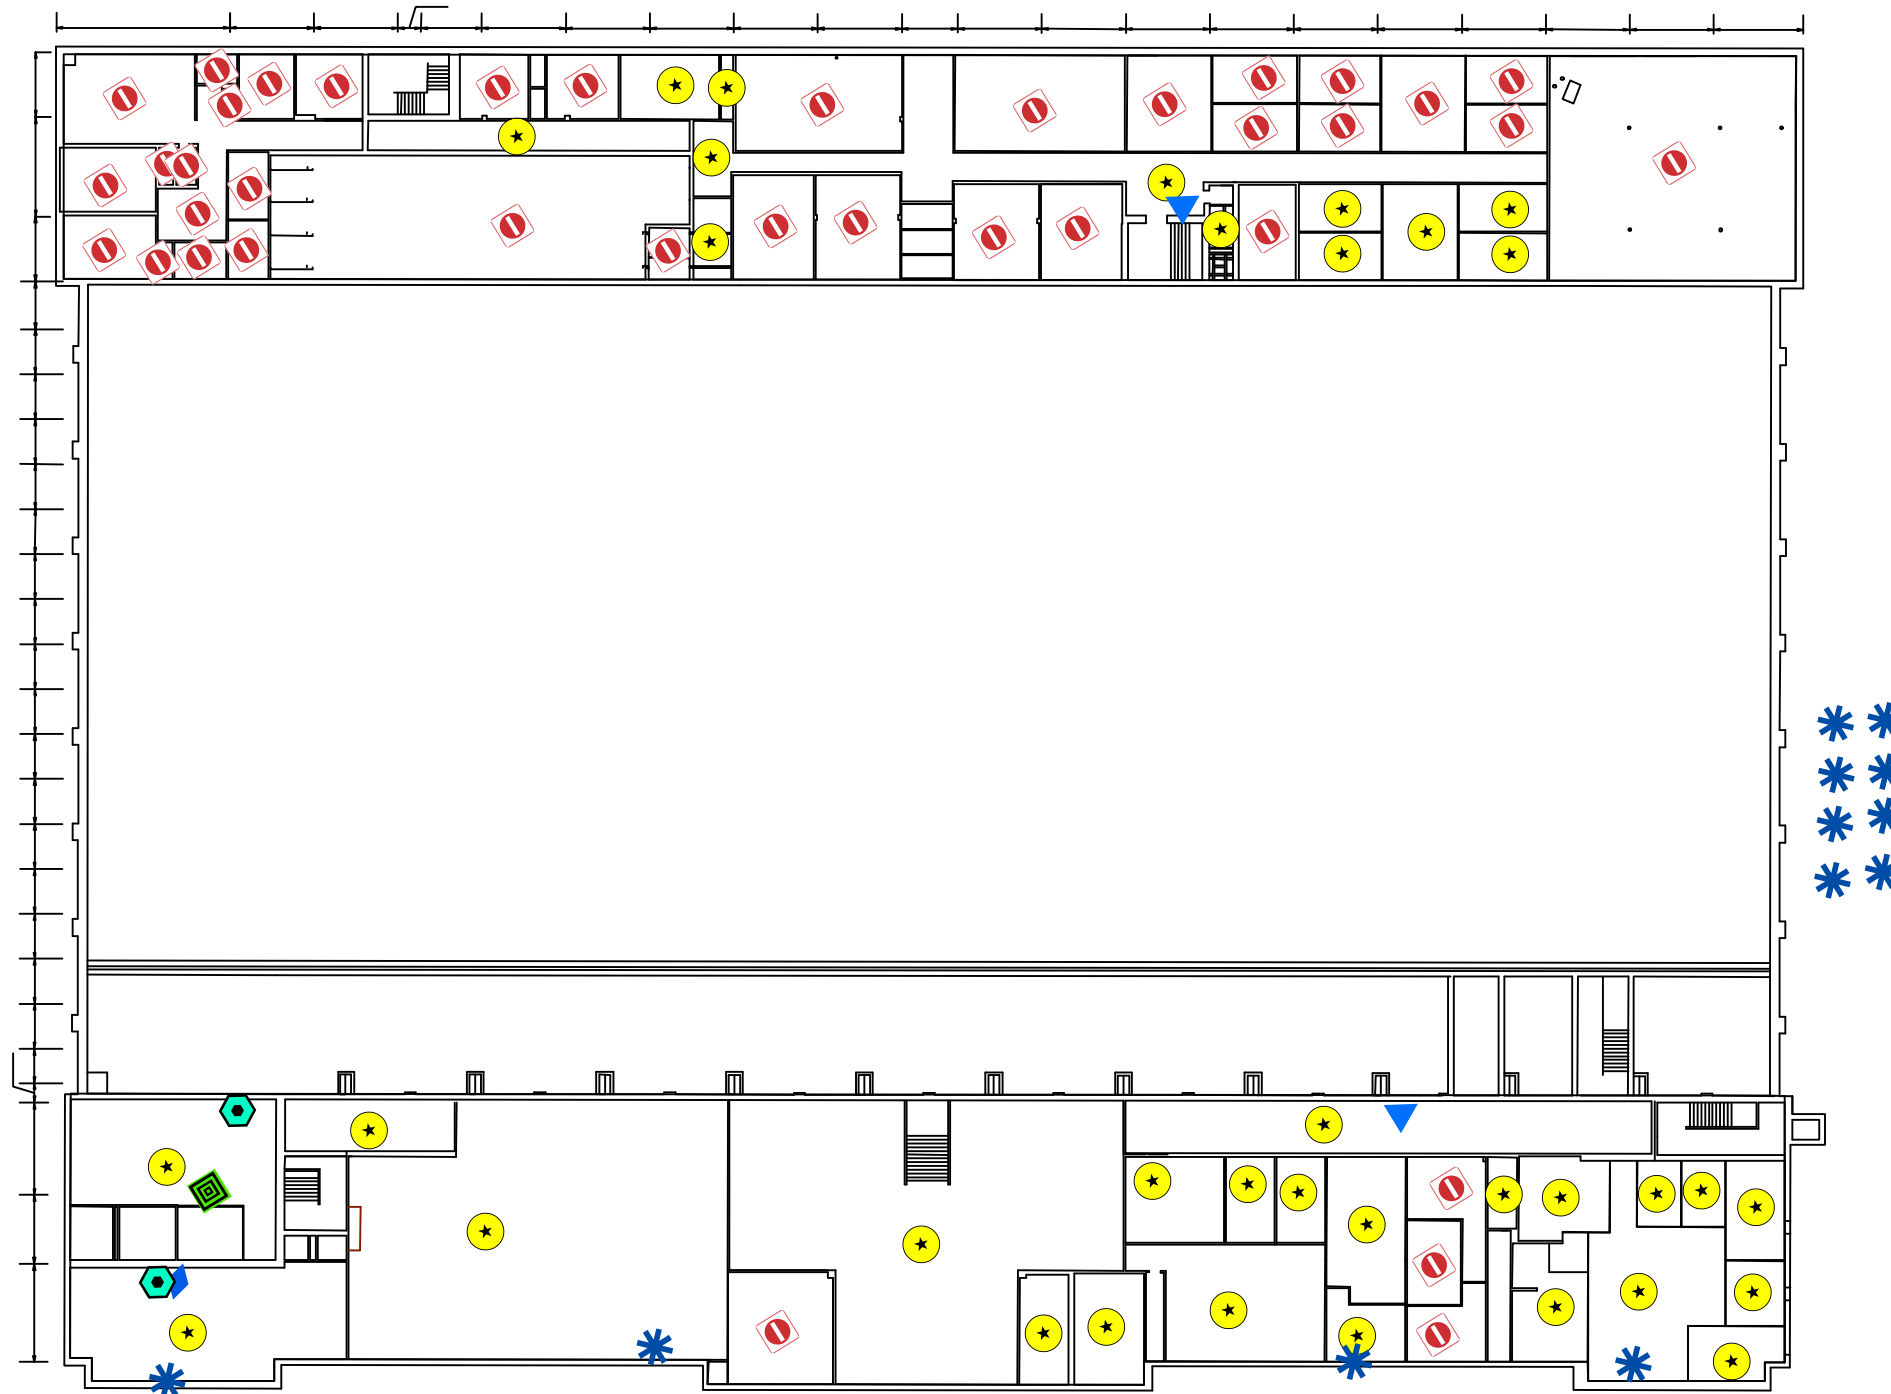


**Rowan
University
&
Stockton
University**

Figure WO2
Site Map with
Site Level Features
West Orange Armory
Floor 2




Legend

West Orange Armory 2nd Floor

-  Air Conditioning Unit
-  Chilled Serving Counter
-  Drinking Water Fountain
-  Ice Machine
-  Light Ballast
-  No Access
-  Refrigeration Unit

0 17.5 35 70 Feet

1 inch = 35 feet

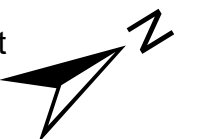

Notes:

Floor plans georeferenced via headsup digitizing over 2015 aerial photography
 Locations of air emissions, ODS, and FLBs georeferenced via floor plans










 



Scale: 1 inch = 35 feet
 File: WO2
 Date: 5/21/2019
 Created By: Rosalie Hood,
 Anne Timmreck,
 Raina Ryan,
 Alexandria Petrosch


Rowan
University
&
Stockton
University

**Figure WO3
Site Map with
Site Level Features
West Orange CSMS1
Floor 1**

Legend

West Orange CSMS1 1st Floor

 
-  Air Conditioning Unit
-  Boiler
-  Flammable Cabinet
-  Ice Machine
-  Infrared Heater
-  Light Ballast
-  No Access
-  Parts Washer
-  Refrigeration Unit
-  Sand Blasting Operation
-  Vehicle Recovery Air Conditioning Unit




Notes:

Floor plans georeferenced via headsup digitizing over 2015 aerial photography
Locations of air emissions, ODS, and FLBs georeferenced via floor plans





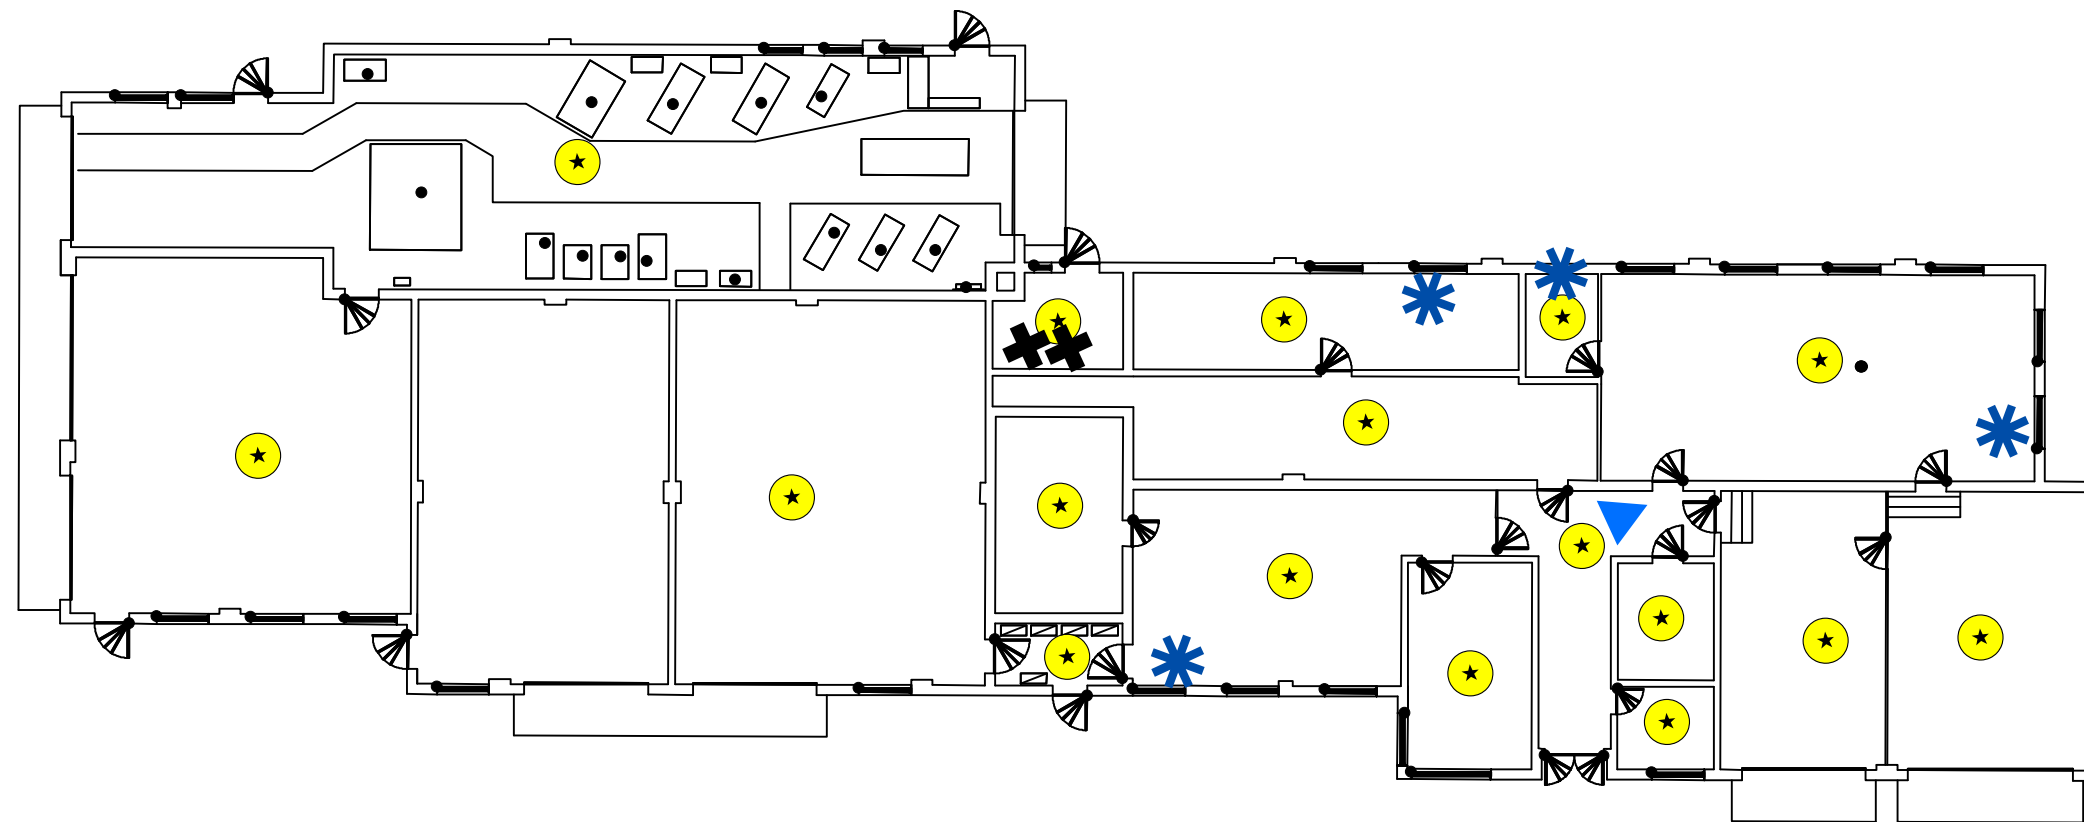

	Scale: 1 inch = 25 feet	Rowan University & Stockton University
	File: WO3	
	Date: 5/21/2019	
	Created By: Rosalie Hood, Anne Timmreck, Raina Ryan, Alexandria Petrosch	

**Figure WO4
Site Map with
Site Level Features
West Orange CSMS 2
Floor 1**




Legend

West Orange CSMS 2 1st Floor

-  Air Conditioning Unit
-  Boiler
-  Drinking Water Fountain
-  Light Ballast

0 10 20 40
Feet

1 inch = 20 feet

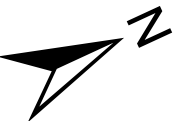

Notes:

Floor plans georeferenced via headsup digitizing over 2015 aerial photography
Locations of air emissions, ODS, and FLBs georeferenced via floor plans







Scale: 1 inch = 20 feet
File: WO4
Date: 5/21/2019
Created By: Rosalie Hood,
Anne Timmreck,
Raina Ryan,
Alexandria Petrosch

**Rowan
University
&
Stockton
University**


**Figure WO5
Site Map with
Site Level Features
West Orange Computer Shop
Floor 1**

Legend


West Orange Computer Shop 1st Floor

-  Air Conditioning Unit
-  Boiler
-  Drinking Water Fountain
-  Light Ballast

0 7.5 15 30 Feet



1 inch = 15 feet

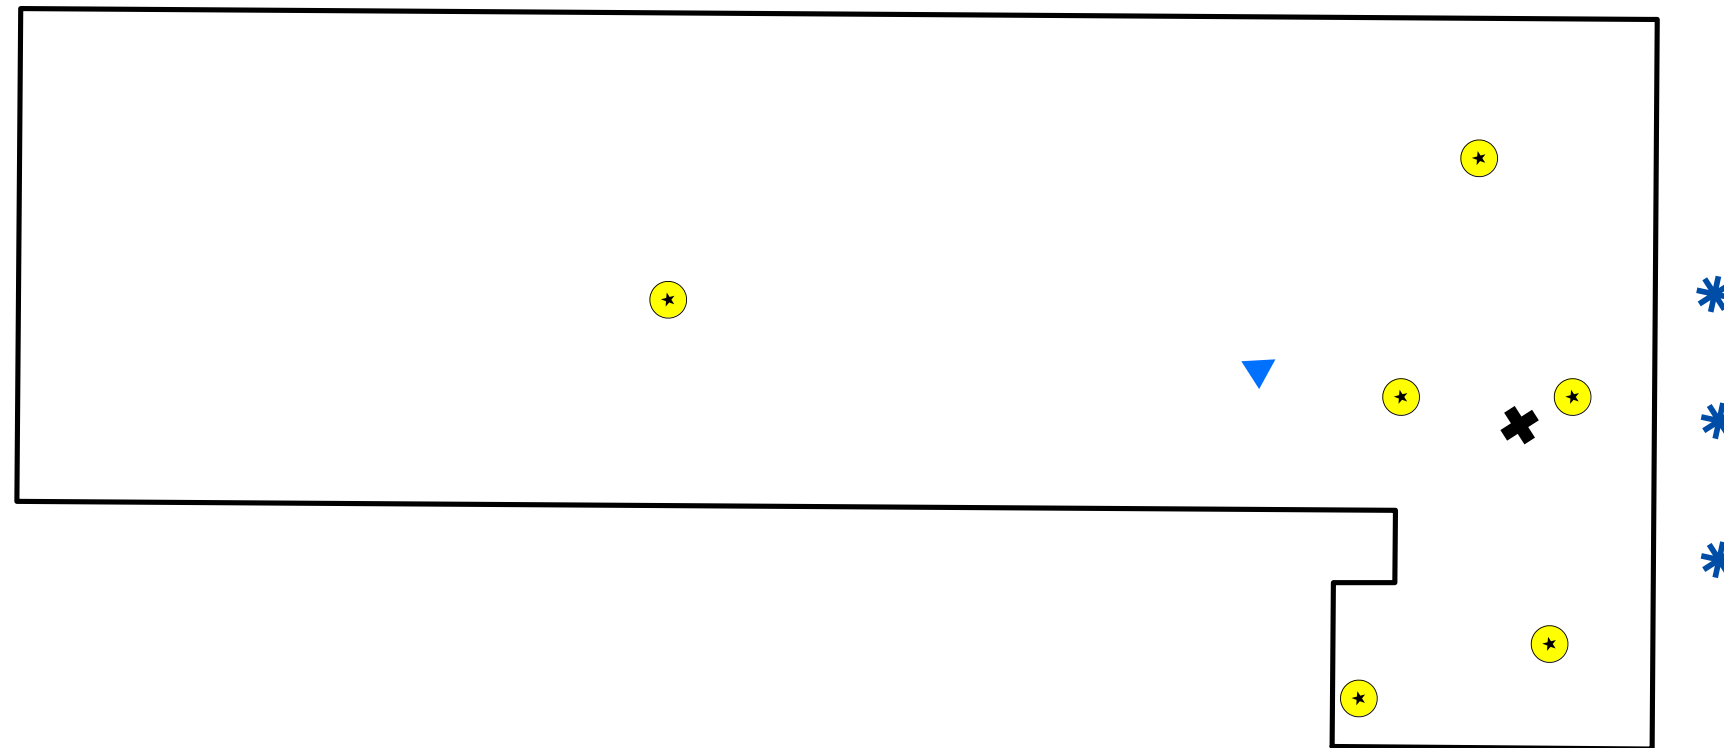

Notes:

Floor plans georeferenced via headsup digitizing over 2015 aerial photography
Locations of air emissions, ODS, and FLBs georeferenced via floor plans



Scale: 1 inch = 15 feet


File: WO5

Date: 5/21/2019

Created By: Rosalie Hood,
Anne Timmreck,
Raina Ryan,
Alexandria Petrosch





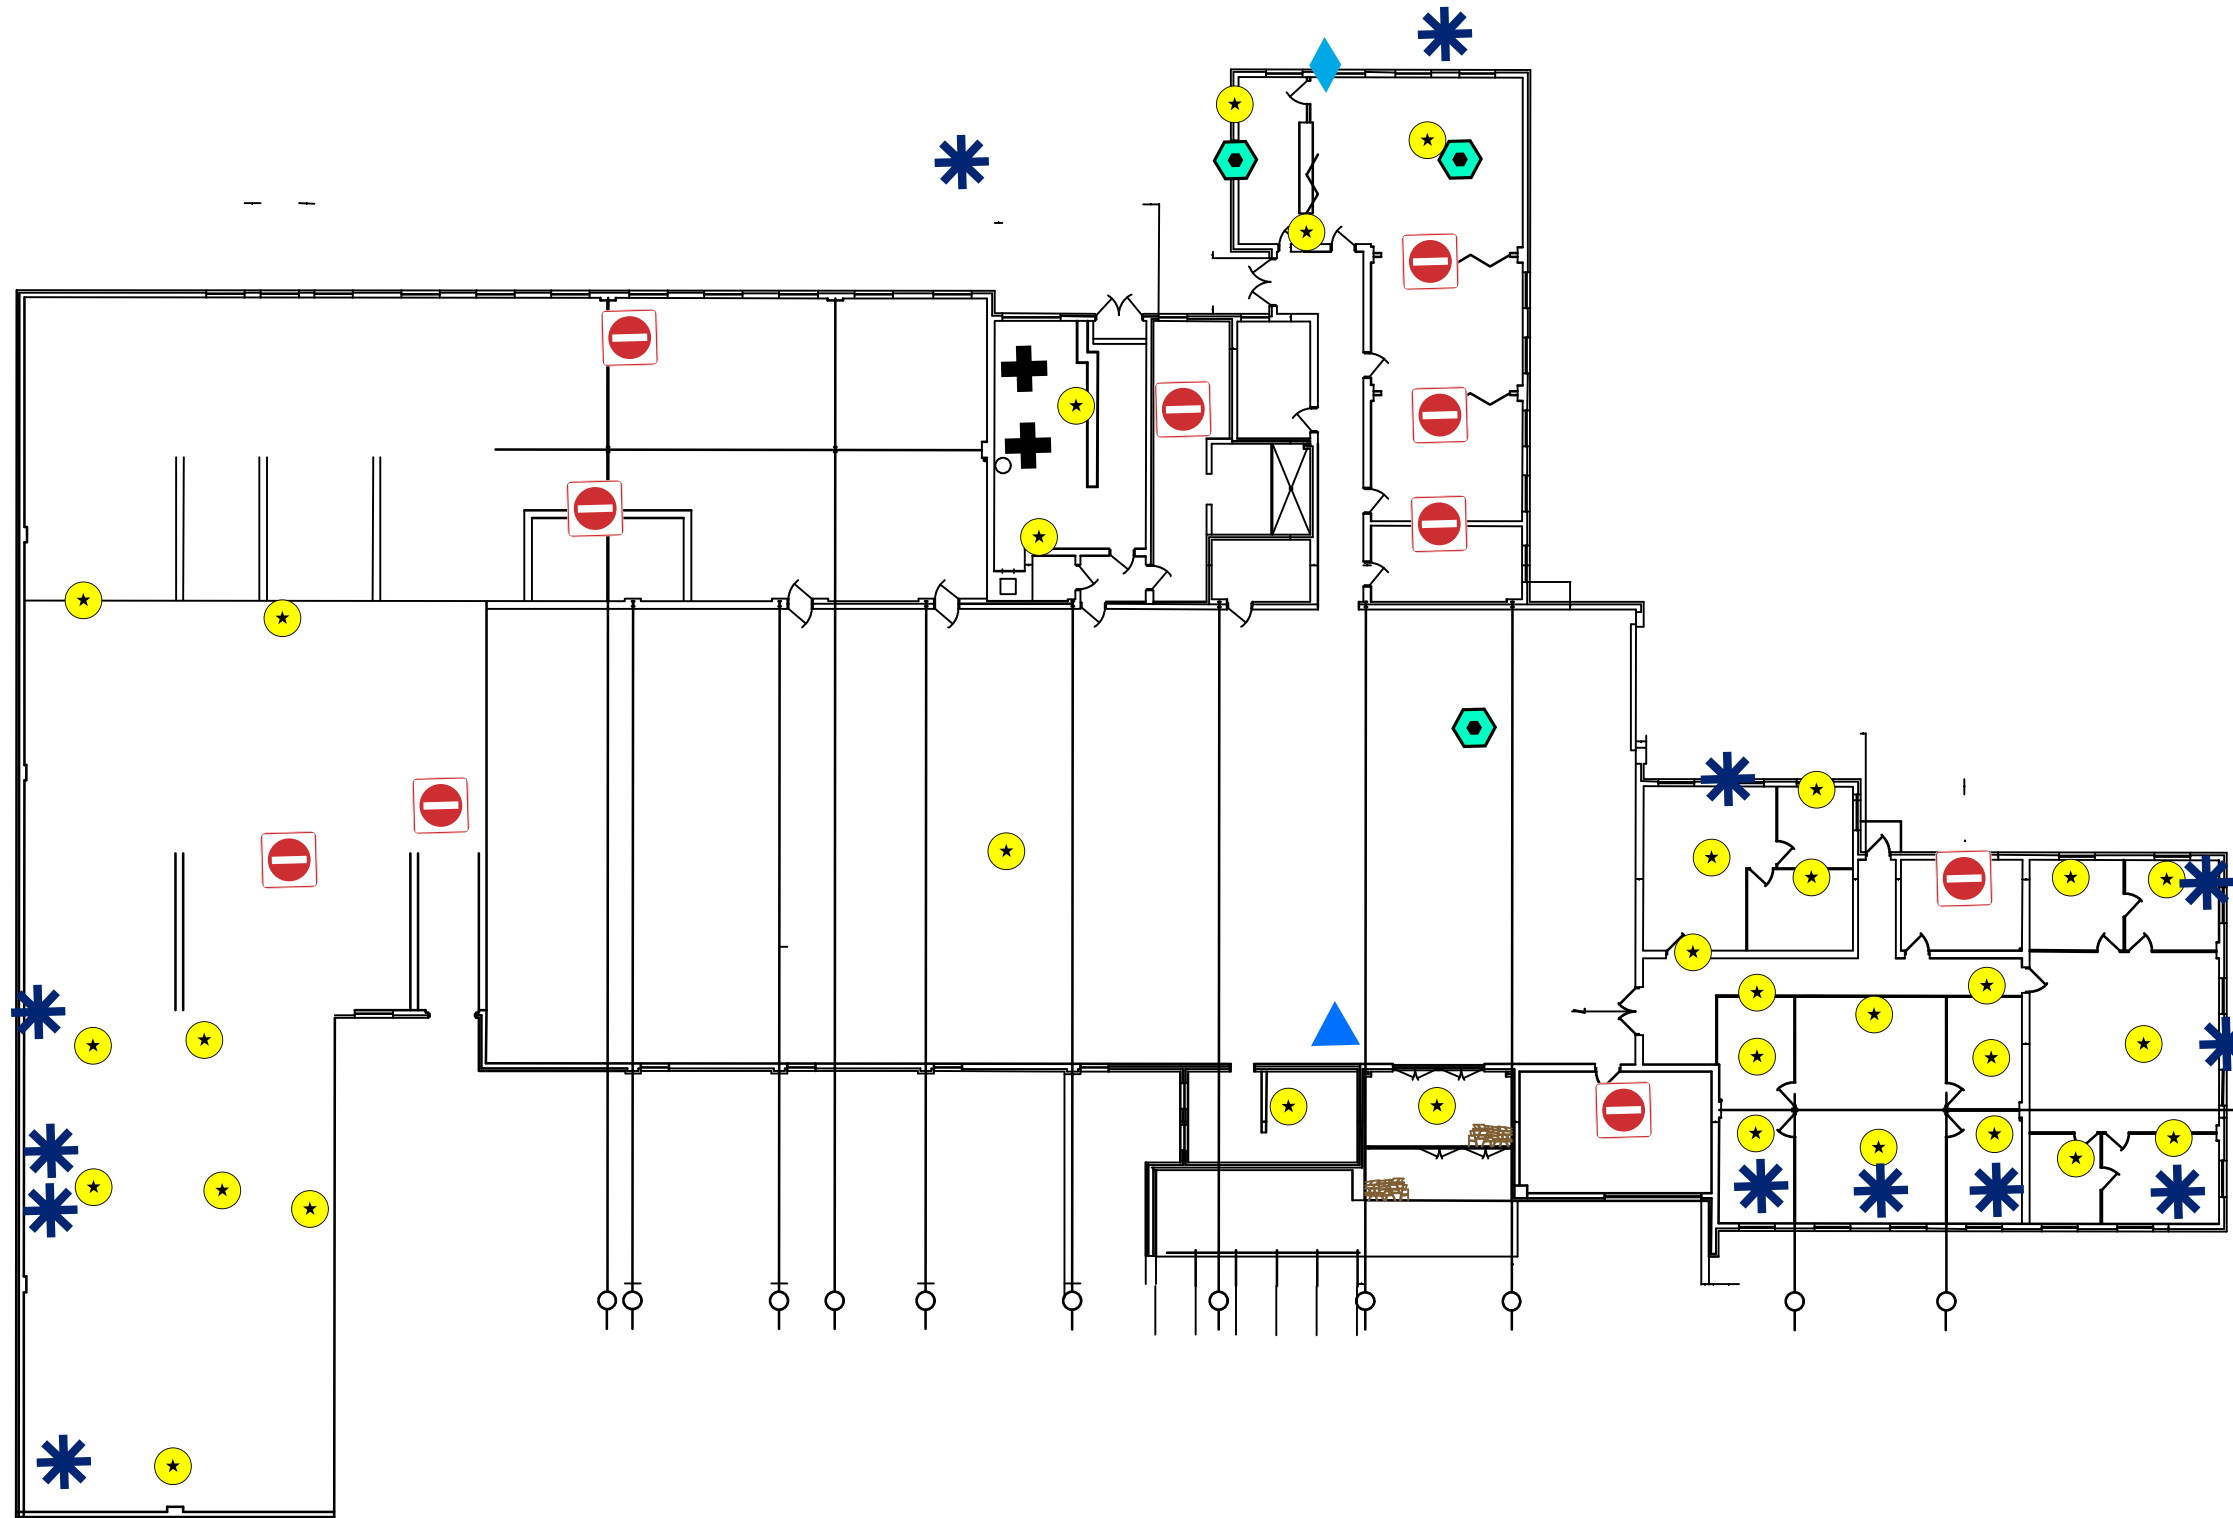


**Rowan
University
&
Stockton
University**


**Figure WE1
Site Map with
Site Level Features
Woodbridge Armory
Floor 1**



Legend

Woodbridge Armory 1st Floor

-  Air Conditioning Unit
-  Boiler
-  Drinking Water Fountain
-  Freezer Unit
-  Light Ballast
-  No Access
-  Refrigeration Unit

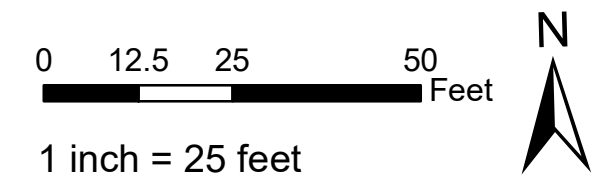

Notes:

Floor plans georeferenced via headsup digitizing over 2015 aerial photography
Locations of air emissions, ODS, and FLBs georeferenced via floor plans



Scale: 1 inch = 25 feet
File: WE1
Date: 5/21/2019
Created By: Rosalie Hood,
Anne Timmreck,
Raina Ryan,
Alexandria Petrosch

**Rowan
University
&
Stockton
University**

**Figure WY1
Site Map with
Site Level Features
Woodburry Armory
Floor 1**




Legend

Woodburry Armory 1st Floor

- Air Conditioning Unit
- Chilled Serving Counter
- Drinking Water Fountain
- Forced Air Heater
- Ice Machine
- Light Ballast
- No Access
- No FLBs
- Refrigeration Unit
- Unknown Heating/AC Unit

0 10 20 40 Feet

1 inch = 20 feet

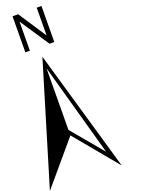

Notes:


Floor plans georeferenced via headsup digitizing over 2015 aerial photography
Locations of air emissions, ODS, and FLBs georeferenced via floor plans





Scale: 1 inch = 20 feet
File: WY1
Date: 5/21/2019
Created By: Jon McKinnon,
Michael Hoffman,
Alexandria Petros


Rowan
University
&
Stockton
University

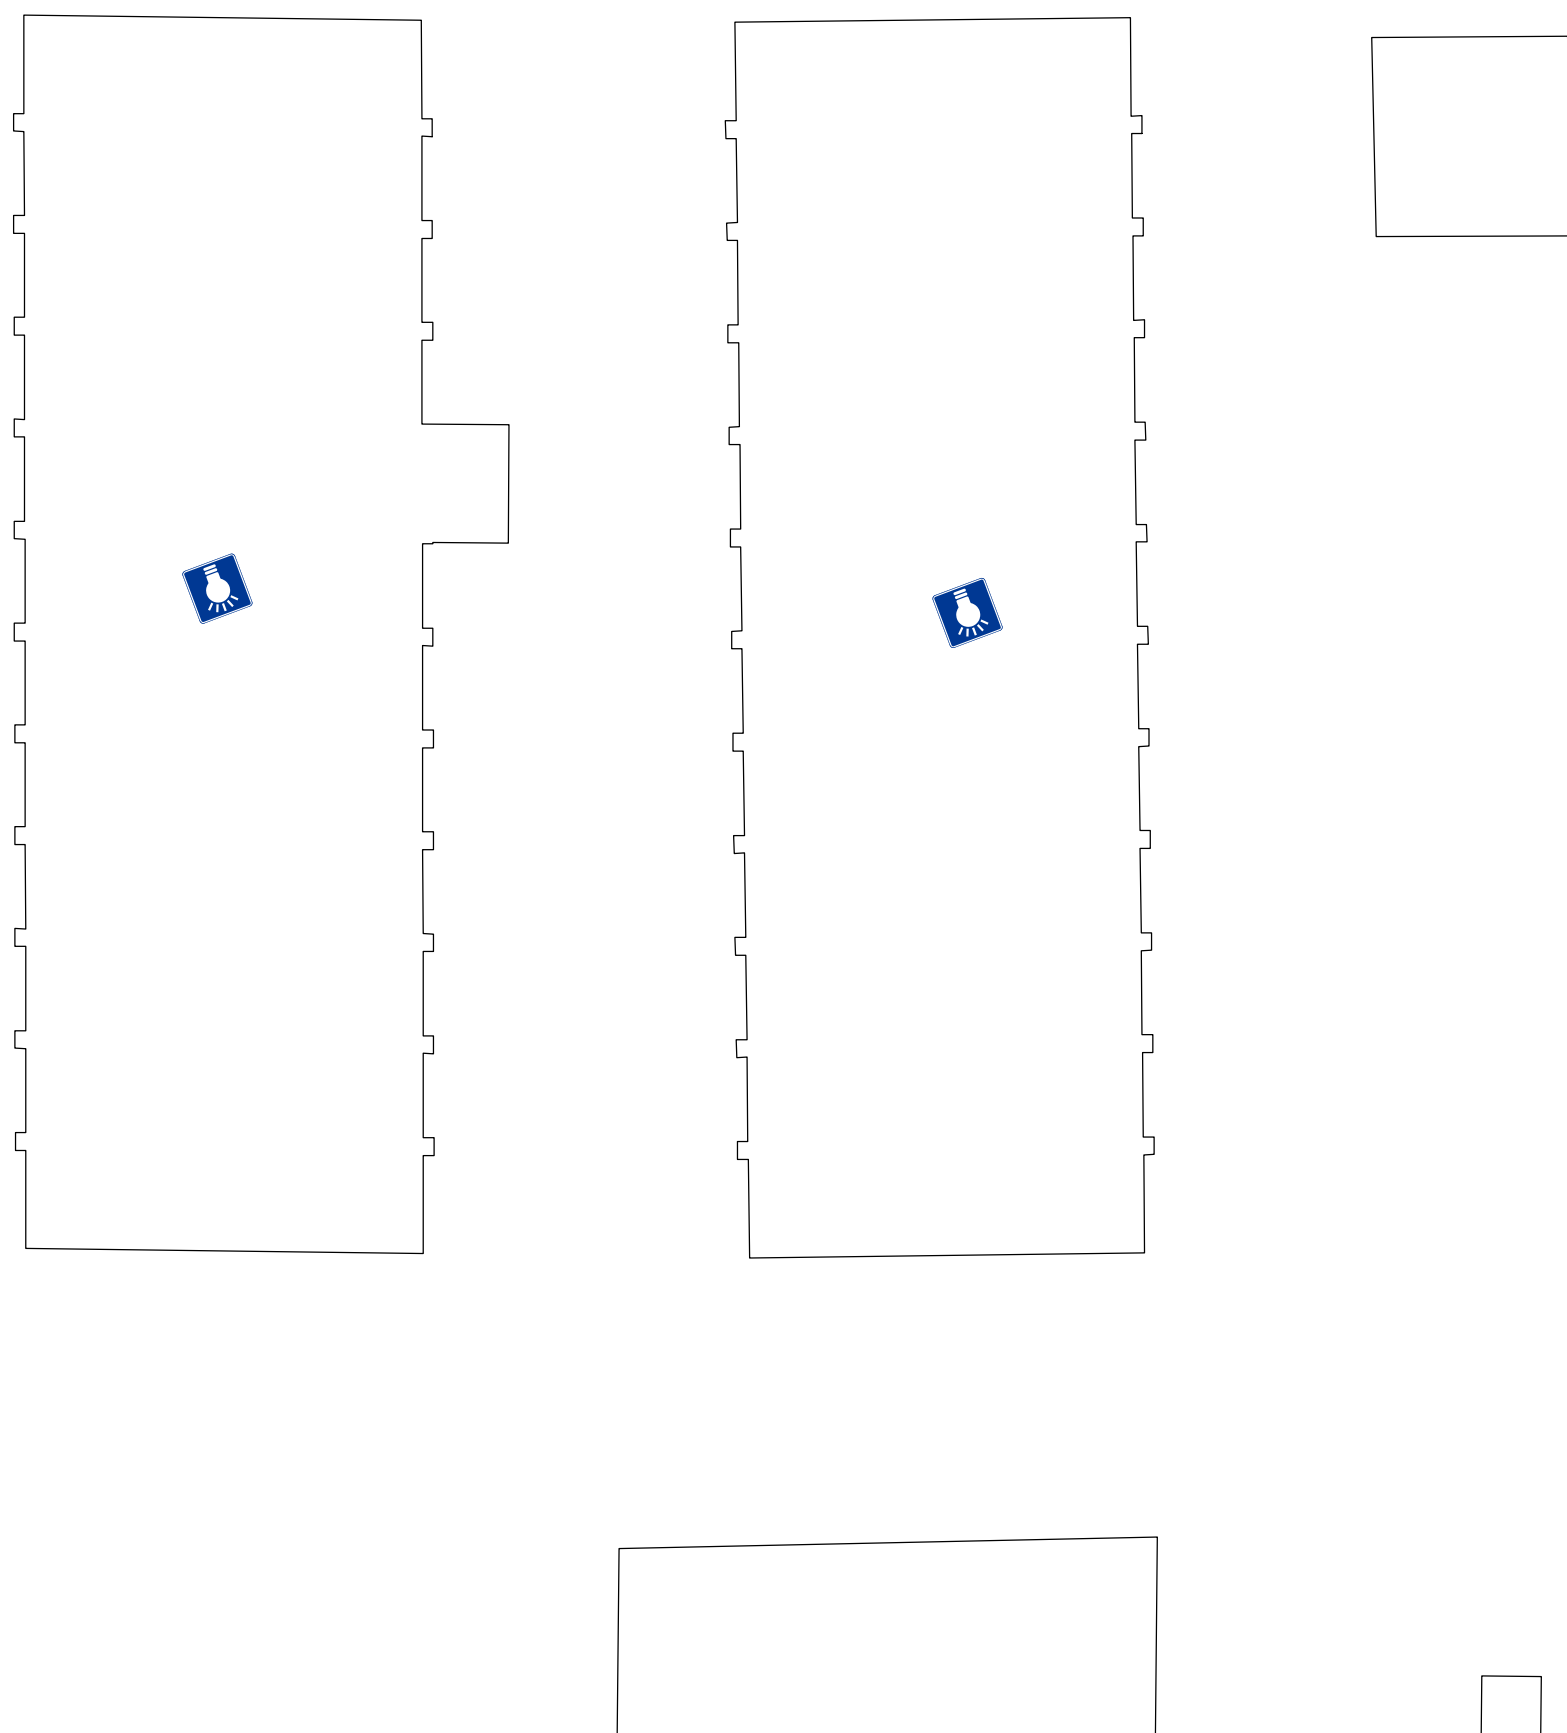**Figure WY2
Site Map with
Site Level Features
Woodbury VSB1 & VSB2
Floor 1**




Legend

 - VS2**
 FLB
- VS2**
 FLB



1 inch = 30 feet

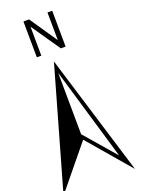

Notes:


Floor plans georeferenced via headsup digitizing over 2015 aerial photography
 Locations of air emissions, ODS, and FLBs georeferenced via floor plans



Scale: 1 inch = 30 feet
 File: WY2
 Date: 5/21/2019
 Created By: Jon McKinnon,
 Alexandria Petrosch

**Rowan
University
&
Stockton
University**

**Figure WYB
Site Map with
Site Level Features
Woodbury Armory
Basement**

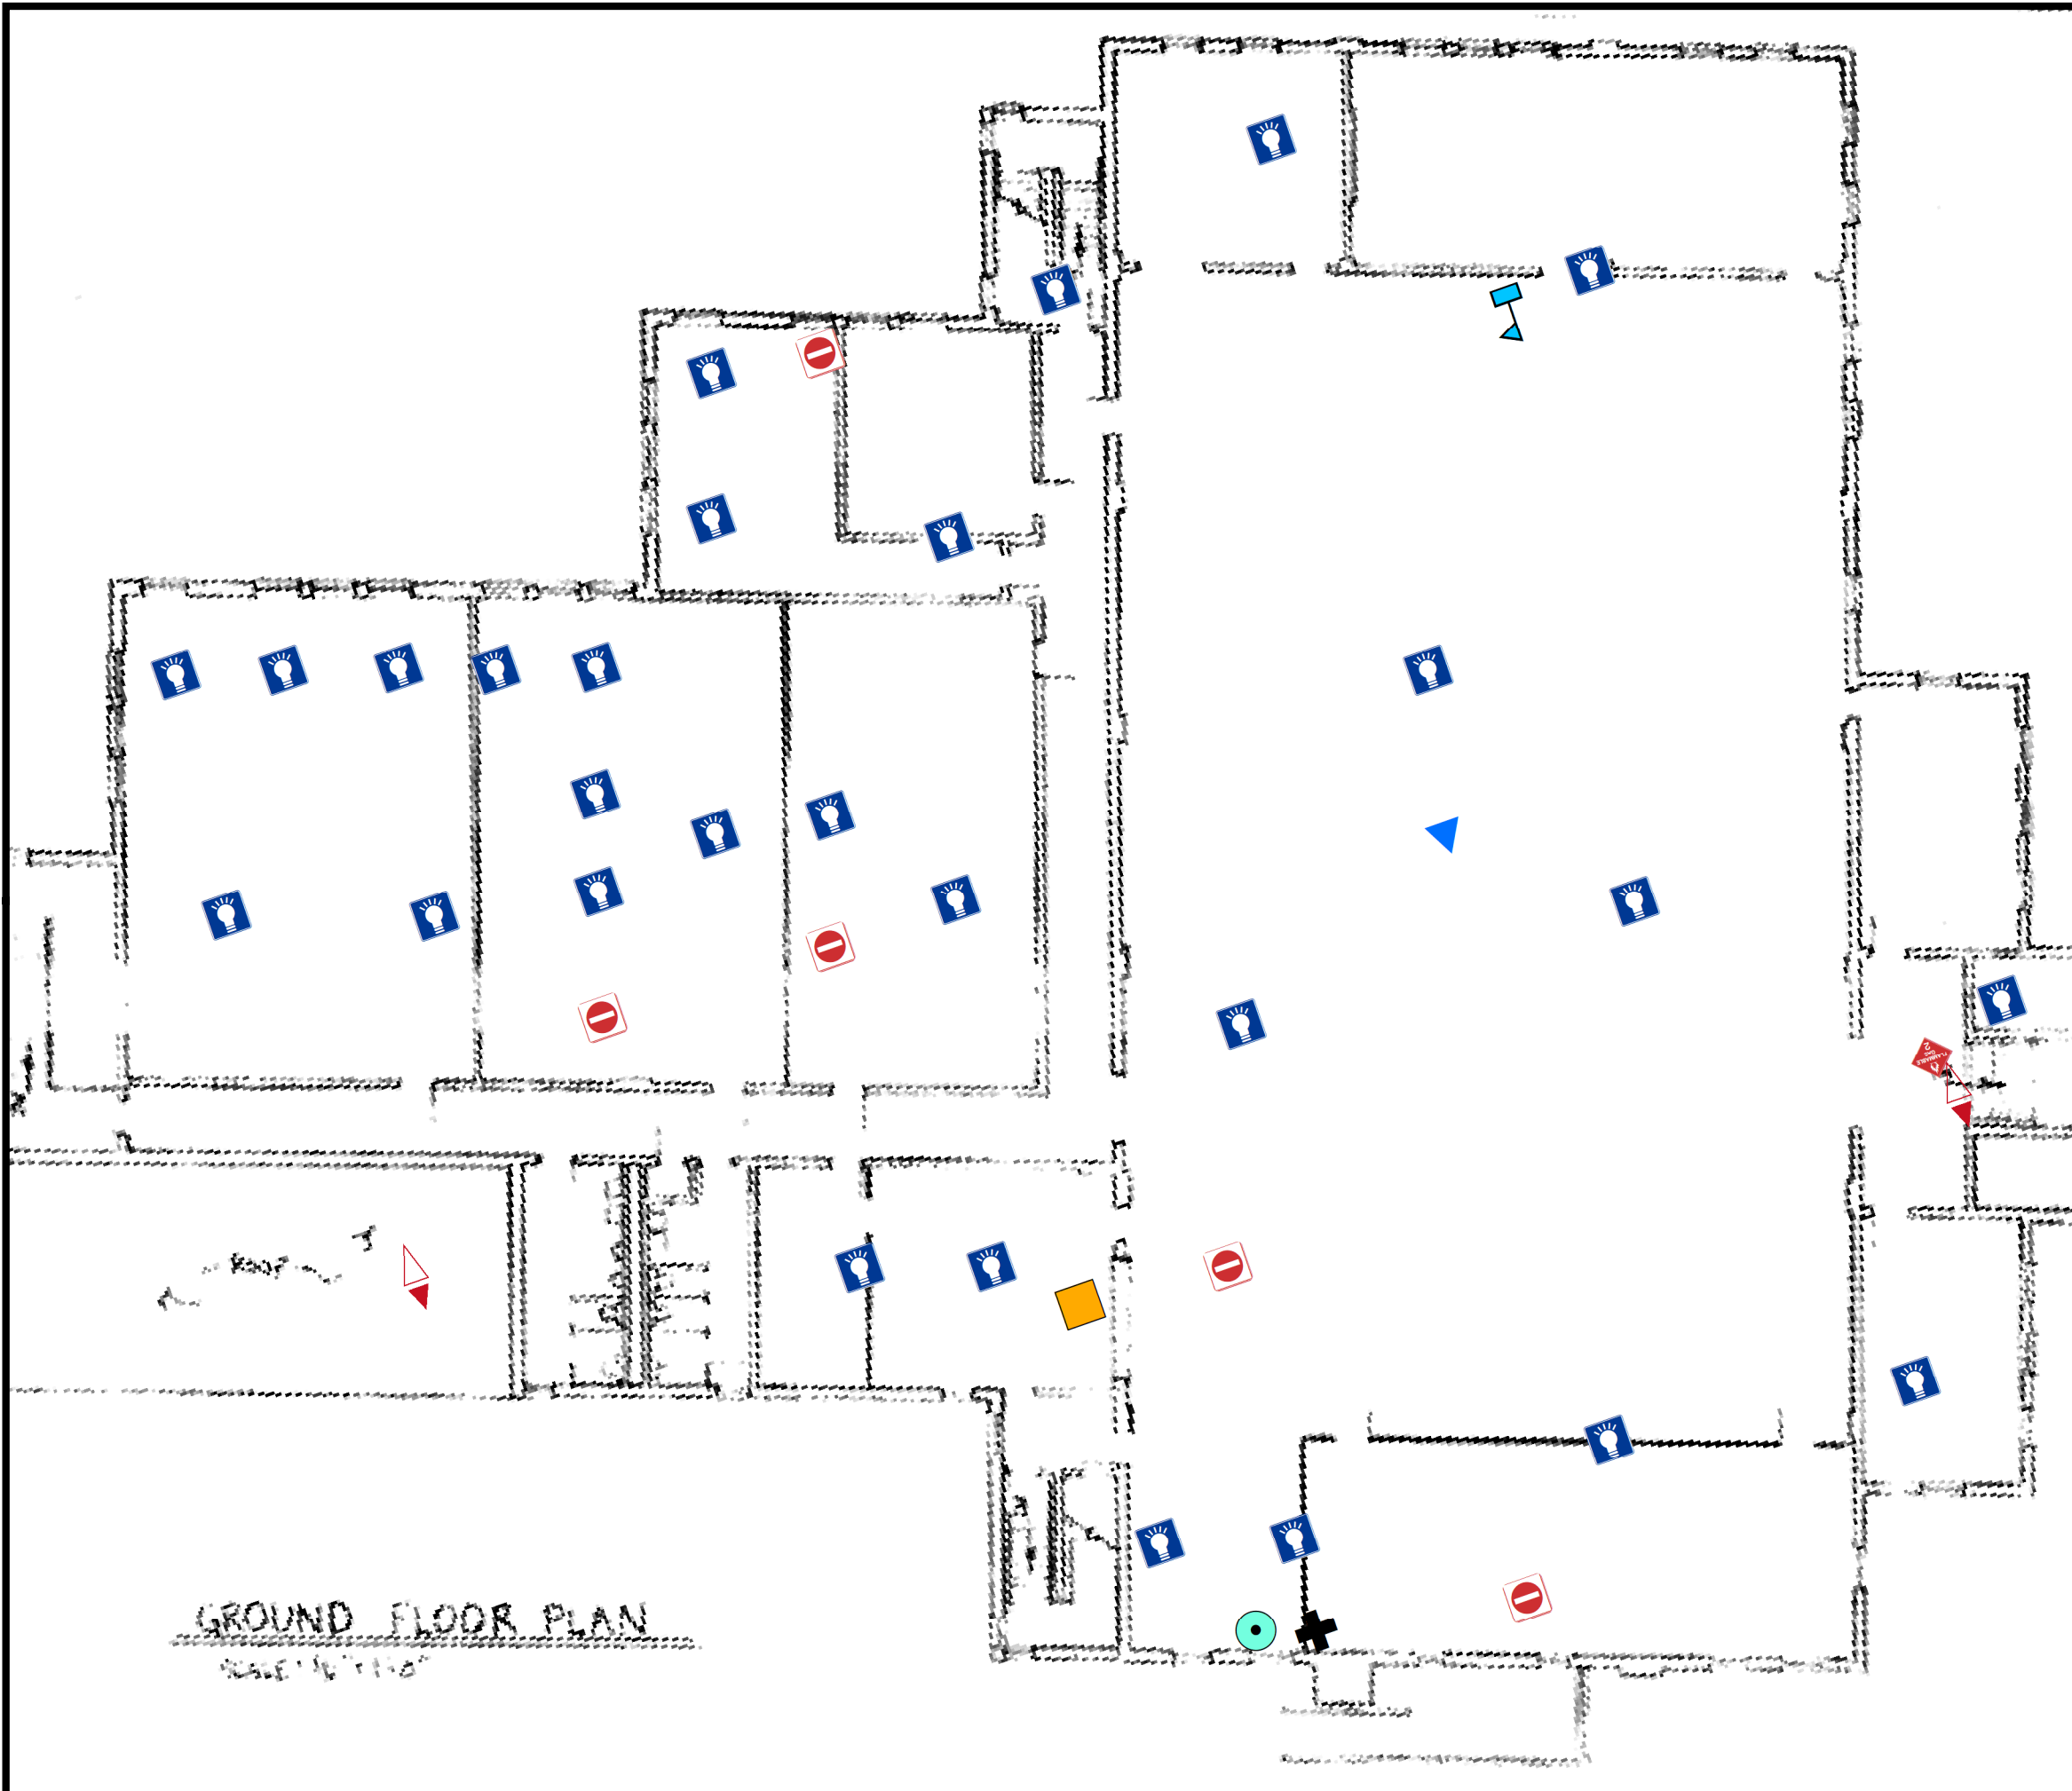

Legend

Basement

- Boiler
- Drinking Water Fountain
- FLB
- Flammable Cabinet
- Forced Air Heater
- Hot Water Heater
- No Access
- No FLBs
- Parts Washer

0 7.5 15 30 Feet
1 inch = 15 feet



Notes:


Floor plans georeferenced via headsup digitizing over 2015 aerial photography
Locations of air emissions, ODS, and FLBs georeferenced via floor plans



Scale: 1 inch = 15 feet
File: WY3
Date: 5/21/2019
Created By: Jon McKinnon,
Tim Ivancich,
Alexandria Petrosch


Rowan
University
&
Stockton
University

**Figure WYO
Site Map with
Site Level Features
Woodbury Armory
Outside**

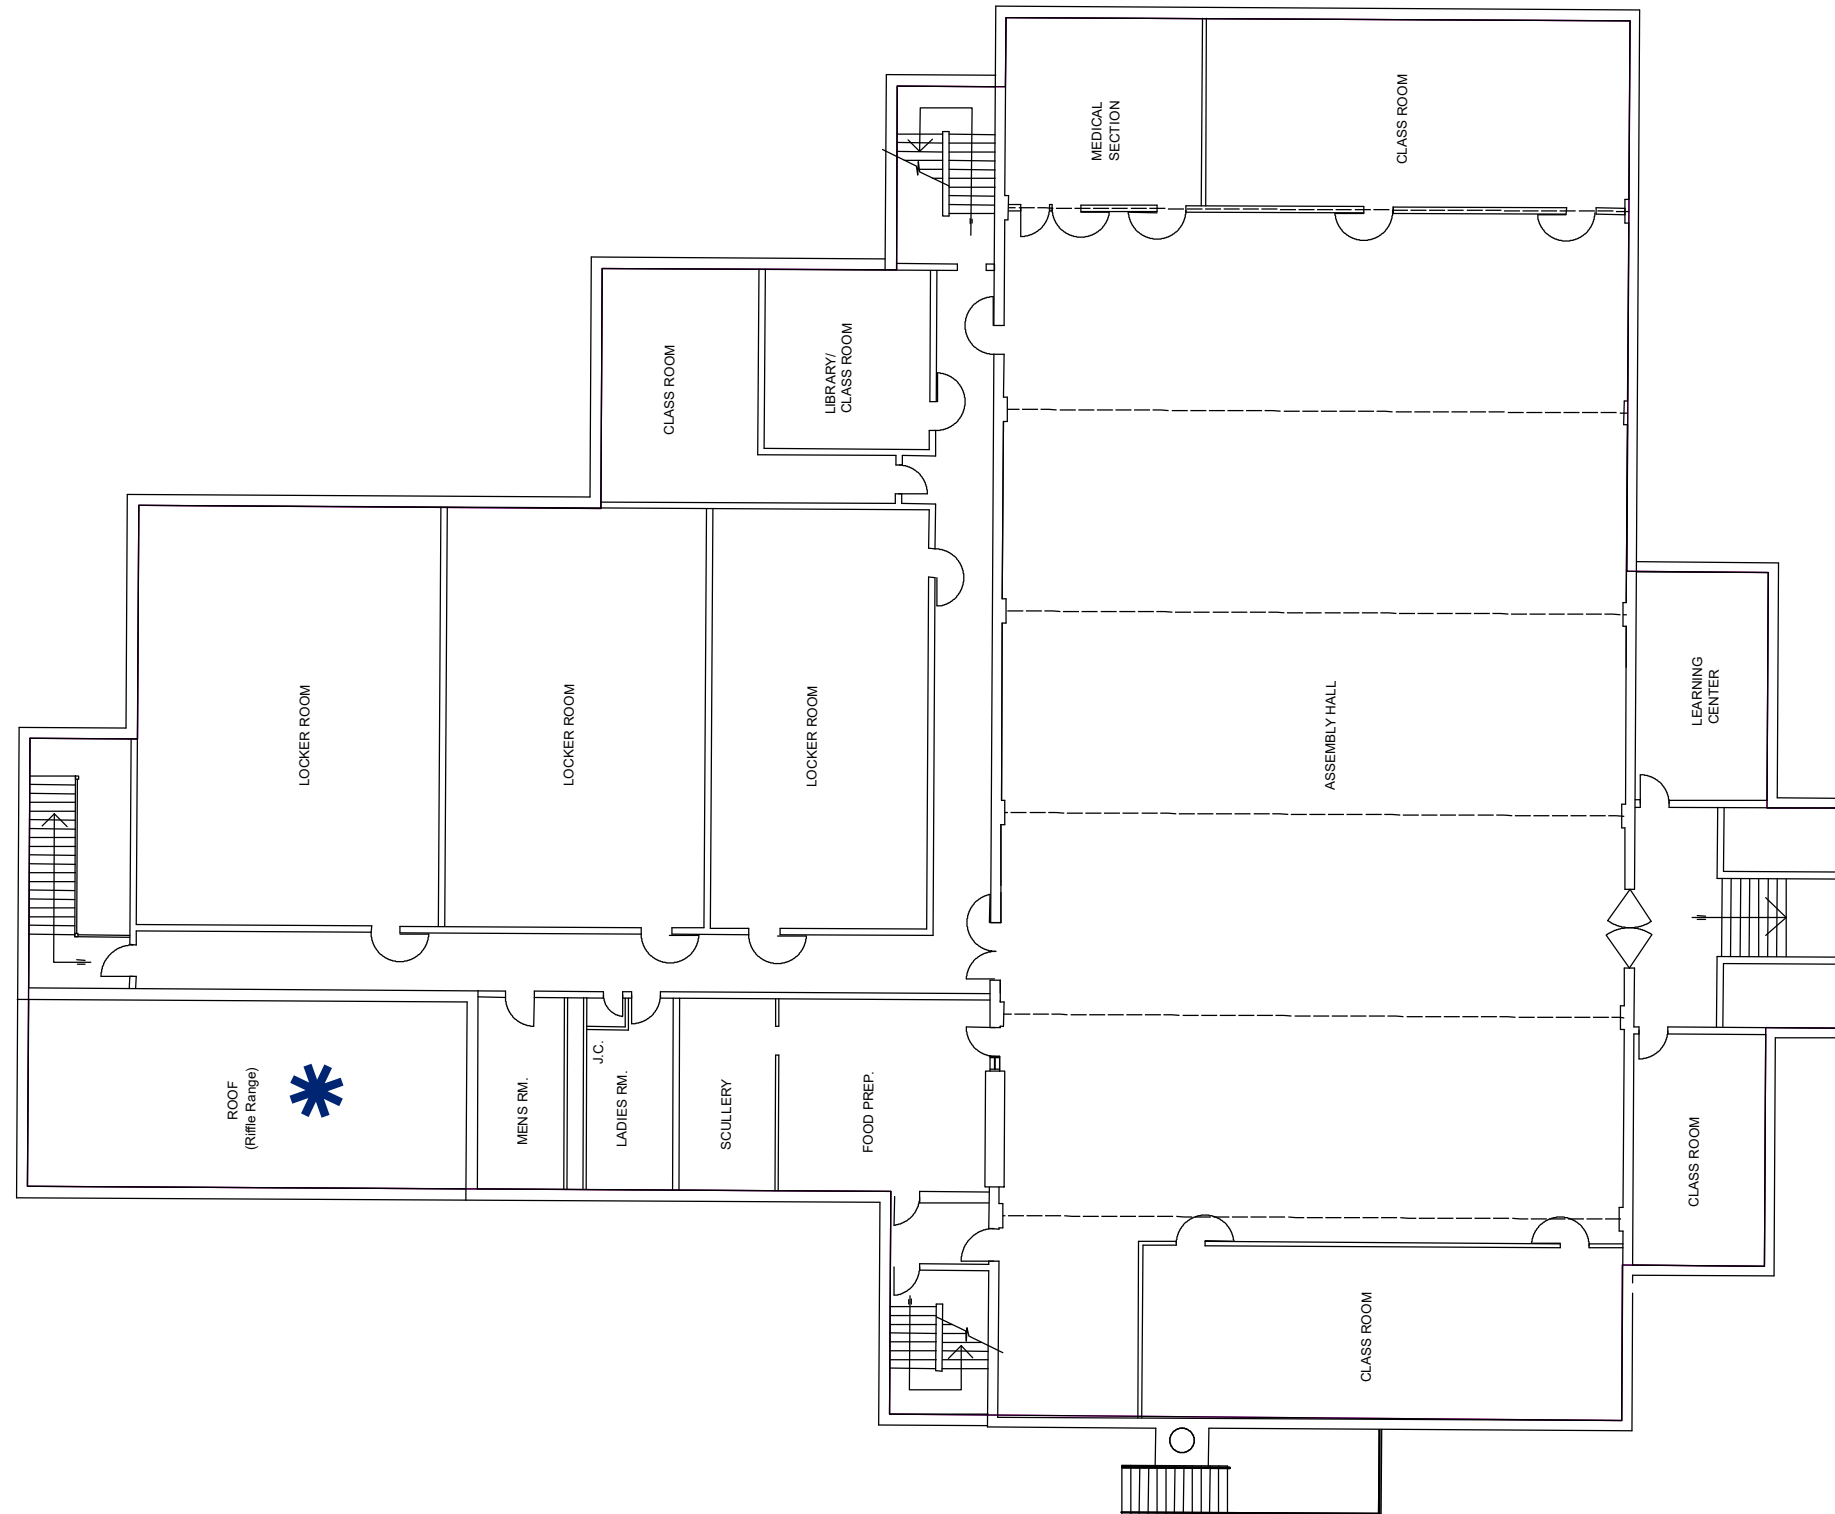

Legend

Outside

 Air Conditioning Condenser Unit

0 10 20 40 Feet

1 inch = 20 feet



Notes:


Floor plans georeferenced via headsup digitizing over 2015 aerial photography
Locations of air emissions, ODS, and FLBs georeferenced via floor plans



Scale: 1 inch = 20 feet
File: WY4
Date: 5/21/2019
Created By: Jon McKinnon,
Alexandria Petrosch

**Rowan
University
&
Stockton
University**

**Figure WN1
Site Map with
Site Level Features
Woodstown Armory
Floor 1**

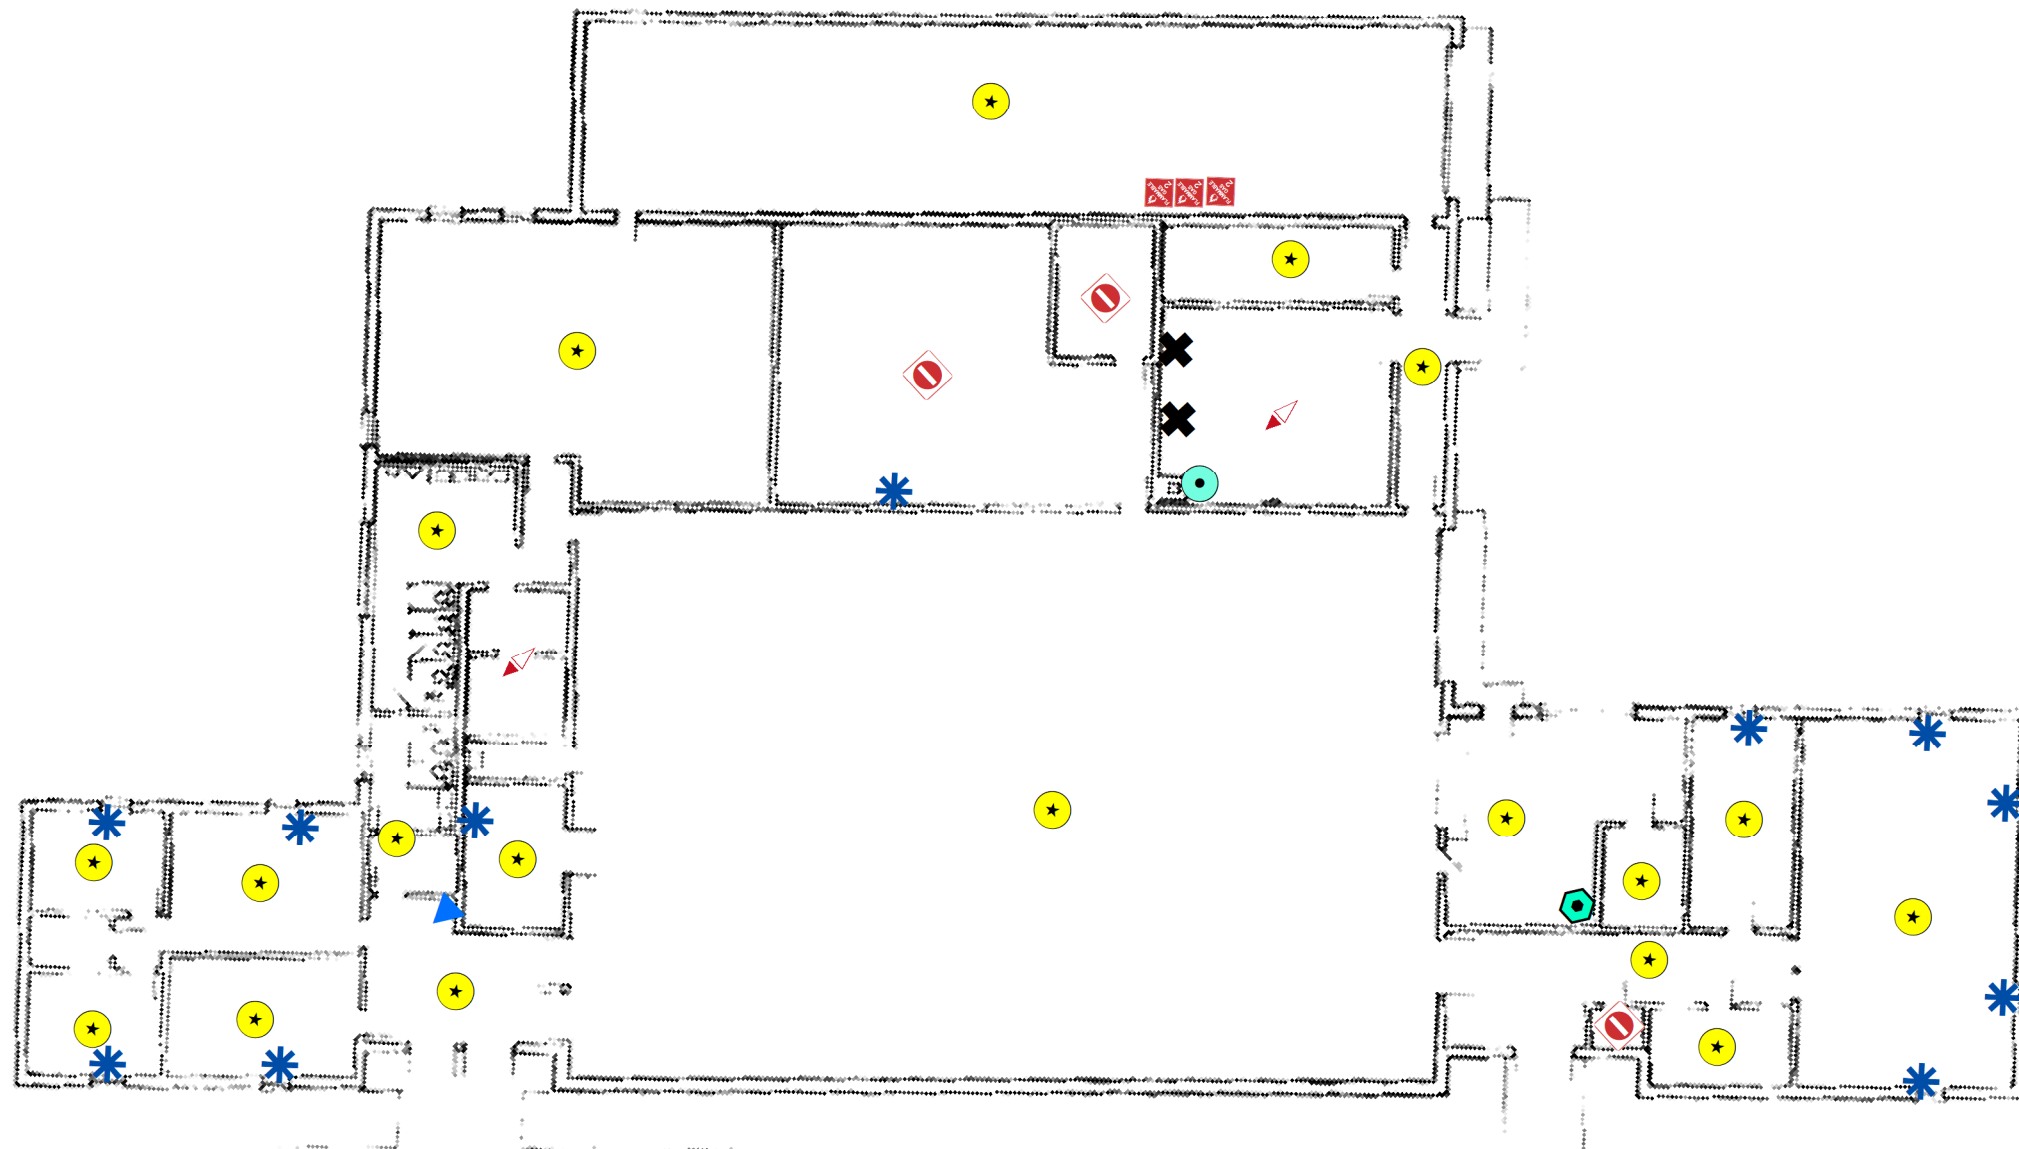

FLOOR PLAN
SCALE 1/4" = 1'-0"

NEW JERSEY DEPARTMENT OF MILITARY AND VETERANS' AFFAIRS + ENGINEERING BUREAU
PROJECT TITLE: _____
DATE: _____

Legend

Woodstown Armory 1st Floor

- Air Conditioning Unit
- Boiler
- Drinking Water Fountain
- Flammable Cabinet
- Hot Water Heater
- Light Ballast
- No Access
- No FLBs
- Refrigeration Unit

0 10 20 40 Feet
1 inch = 20 feet



Notes:

Floor plans georeferenced via headsup digitizing over 2015 aerial photography
Locations of air emissions, ODS, and FLBs georeferenced via floor plans




Scale: 1 inch = 20 feet
File: WN1
Date: 5/21/2019
Created By: Jon McKinnon,
Michael Hoffman,
Alexandria Petrosch

**Rowan
University
&
Stockton
University**




Figure WN2
Site Map with
Site Level Features
Woodstown Armory
Outside

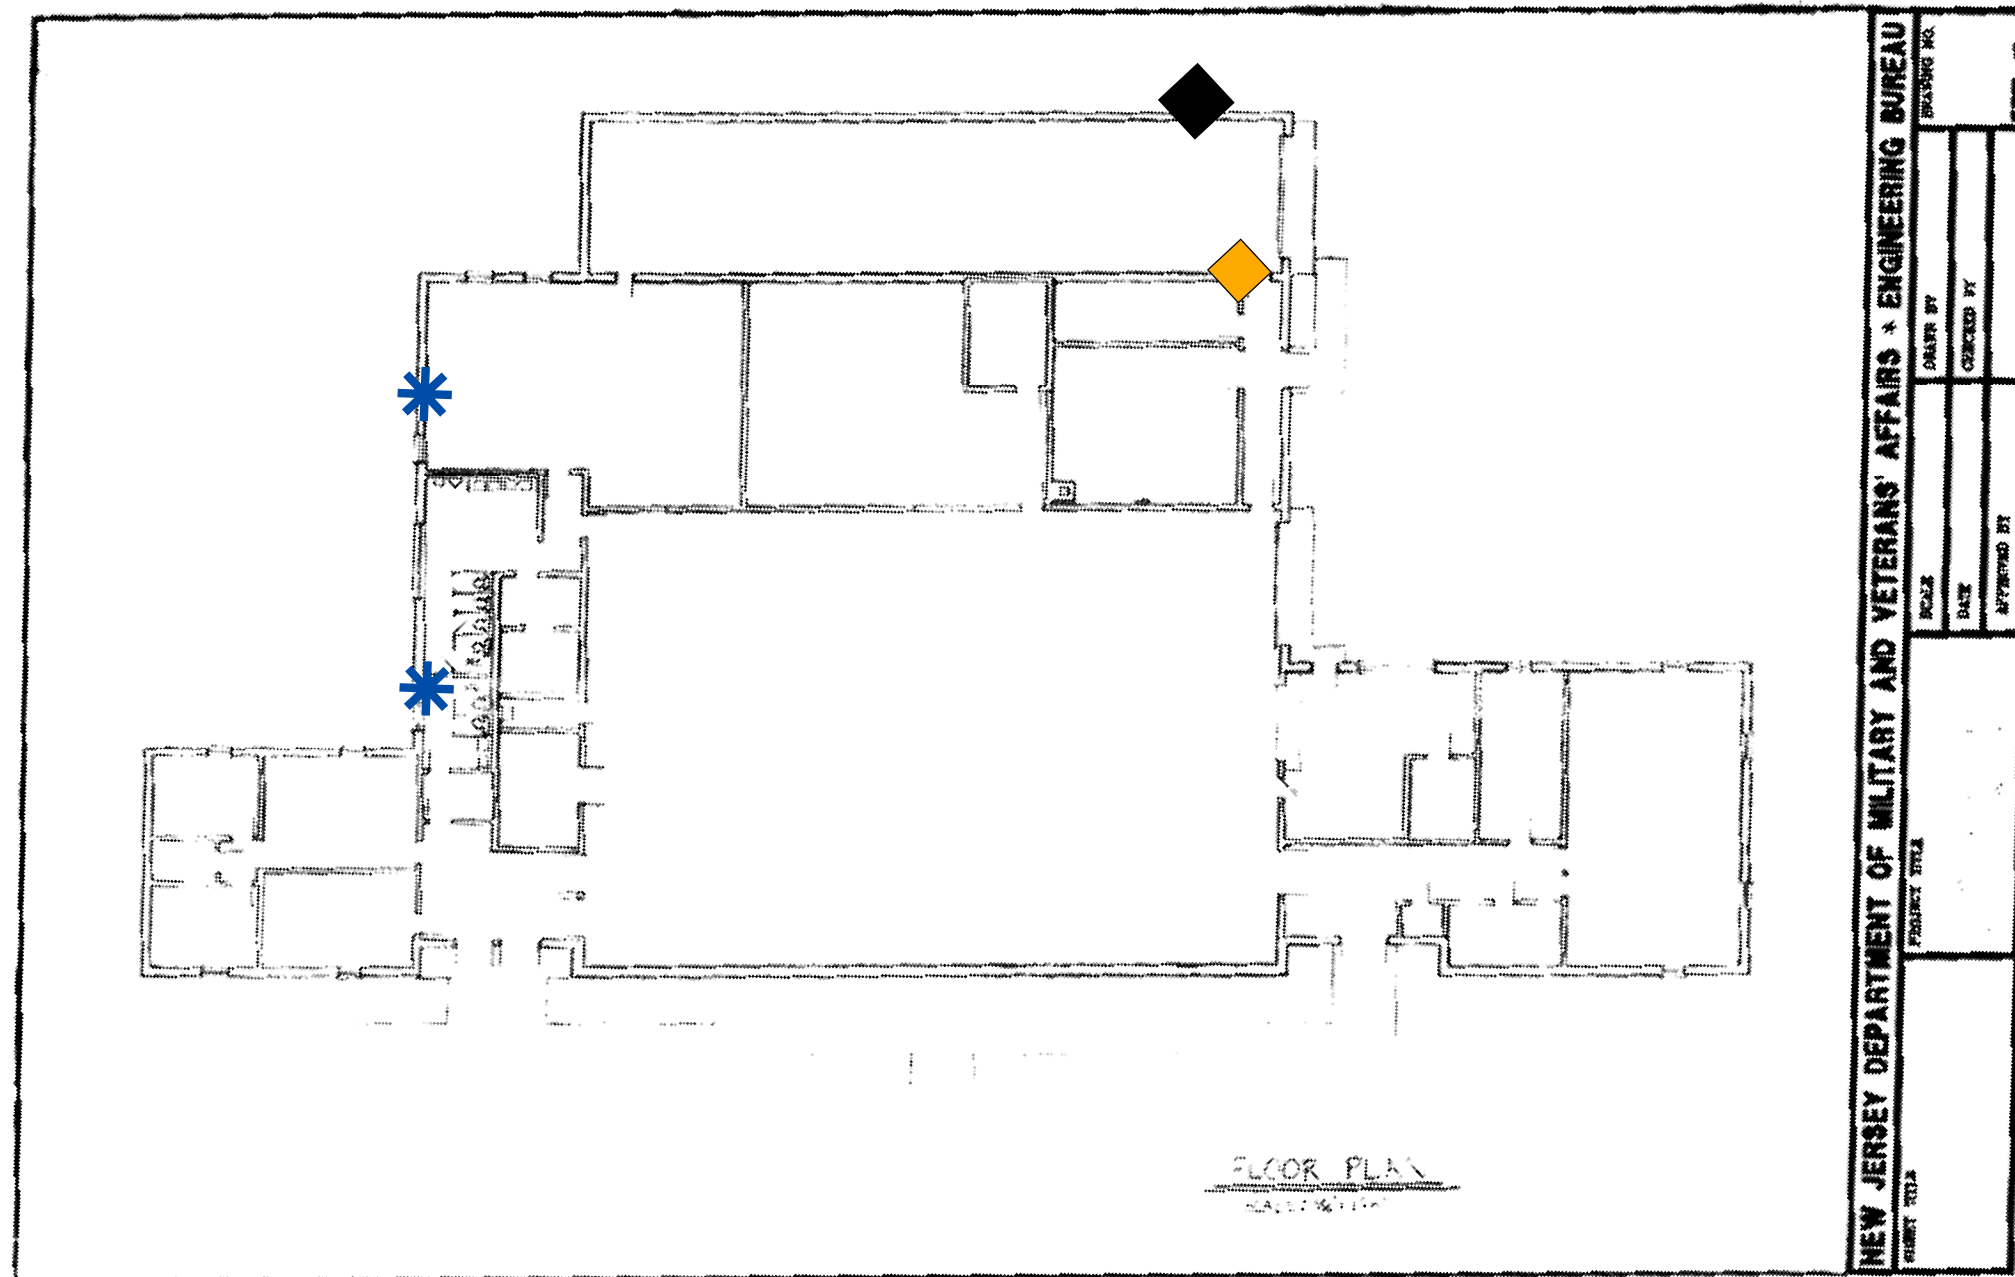

Legend

Woodstown Armory Outside

- Air Conditioning Condenser Unit
- Forced Air Heater
- Hazmat Shed
- Storage Tank

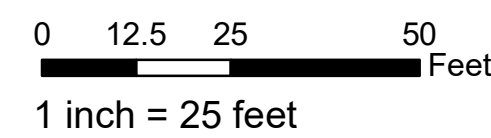

Notes:

Floor plans georeferenced via headsup digitizing over 2015 aerial photography
 Locations of air emissions, ODS, and FLBs georeferenced via floor plans



Scale: 1 inch = 25 feet
 File: WN2
 Date: 5/21/2019
 Created By: Jon McKinnon,
 Michael Hoffman,
 Alexandria Petrosch

Rowan
 University
 &
 Stockton
 University